

[FILE NAME : Z:\17025 HERCULES PARCELS Q+R\6 DRAWING\6.40 CAD\1-SITE\170824_BLOCK Q+R_TN.DWG] [TAB : 34X22 BLDG SECTIONS + TITLE BLOCK] [October 18 - Wednesday 2017 - 6:14pm] [Plotted by : TNGUYEN] [Pen Setting : { Unknown }]
[XREF FILE NAME : :HBCX_TWBDY;:HBCXSITE;:HBEXTOPD;:HBEXUTIL;HERCULES_MUIRPOINTELAYOUT;:JMPPRPLAN;:JMPPRUTIL;UNIT 1A;:UNIT 1B;:UNIT 1E;:UNIT 1J R A;:UNIT 1J R B;:UNIT 2A;:UNIT 2B;:UNIT 2C;:UNIT 2C MOD 1;:UNIT 2D;:UNIT 2F;:UNIT 2G;:UNIT 3A;:W3422PER;:W3422PERLOG]


HERCULES PARCELS Q & R

HERCULES, CA

LIGHTING SCHEDULE

SYMBOL	DESCRIPTION	IMAGE
	IN-GRADE TREE UPLIGHTS	
	IN-GRADE PATH LIGHTS	
	LINEAR LED ACCENT LIGHTING	
	STREET LIGHTS TO MATCH EXISTING (NOT IN SCOPE) EXISTING LIGHTS	

[FILE NAME: Z:\17025 HERCULES PARCELS Q&R6 DRAWING\6.40 CAD\1-SITE\170254 BLOCK Q&R TNDWG] [TAB: 34X22 BLDG SECTIONS + TITLE BLOCK] [October 18 - Wednesday 2017 - 6:14pm] [Plotted by: TNGUYEN] [Pen Setting: {Unknown}]
[XREF FILE NAME: -HBCX_TWBODY; -HBCX_TWEBSITE; -HBCX_TOPO; -HBCX_UTIL; -HERCULES_MUIRPOINT_LAYOUT; -MUIRPLAN; -MUIRUTIL; UNIT 1A; UNIT 1B; UNIT 1E; UNIT 1R A; UNIT 1R B; UNIT 2A; UNIT 2B; UNIT 2C; UNIT 2C MOD 1; UNIT 2D; UNIT 2F; UNIT 3A; W3422PER; W3422PERLOG]

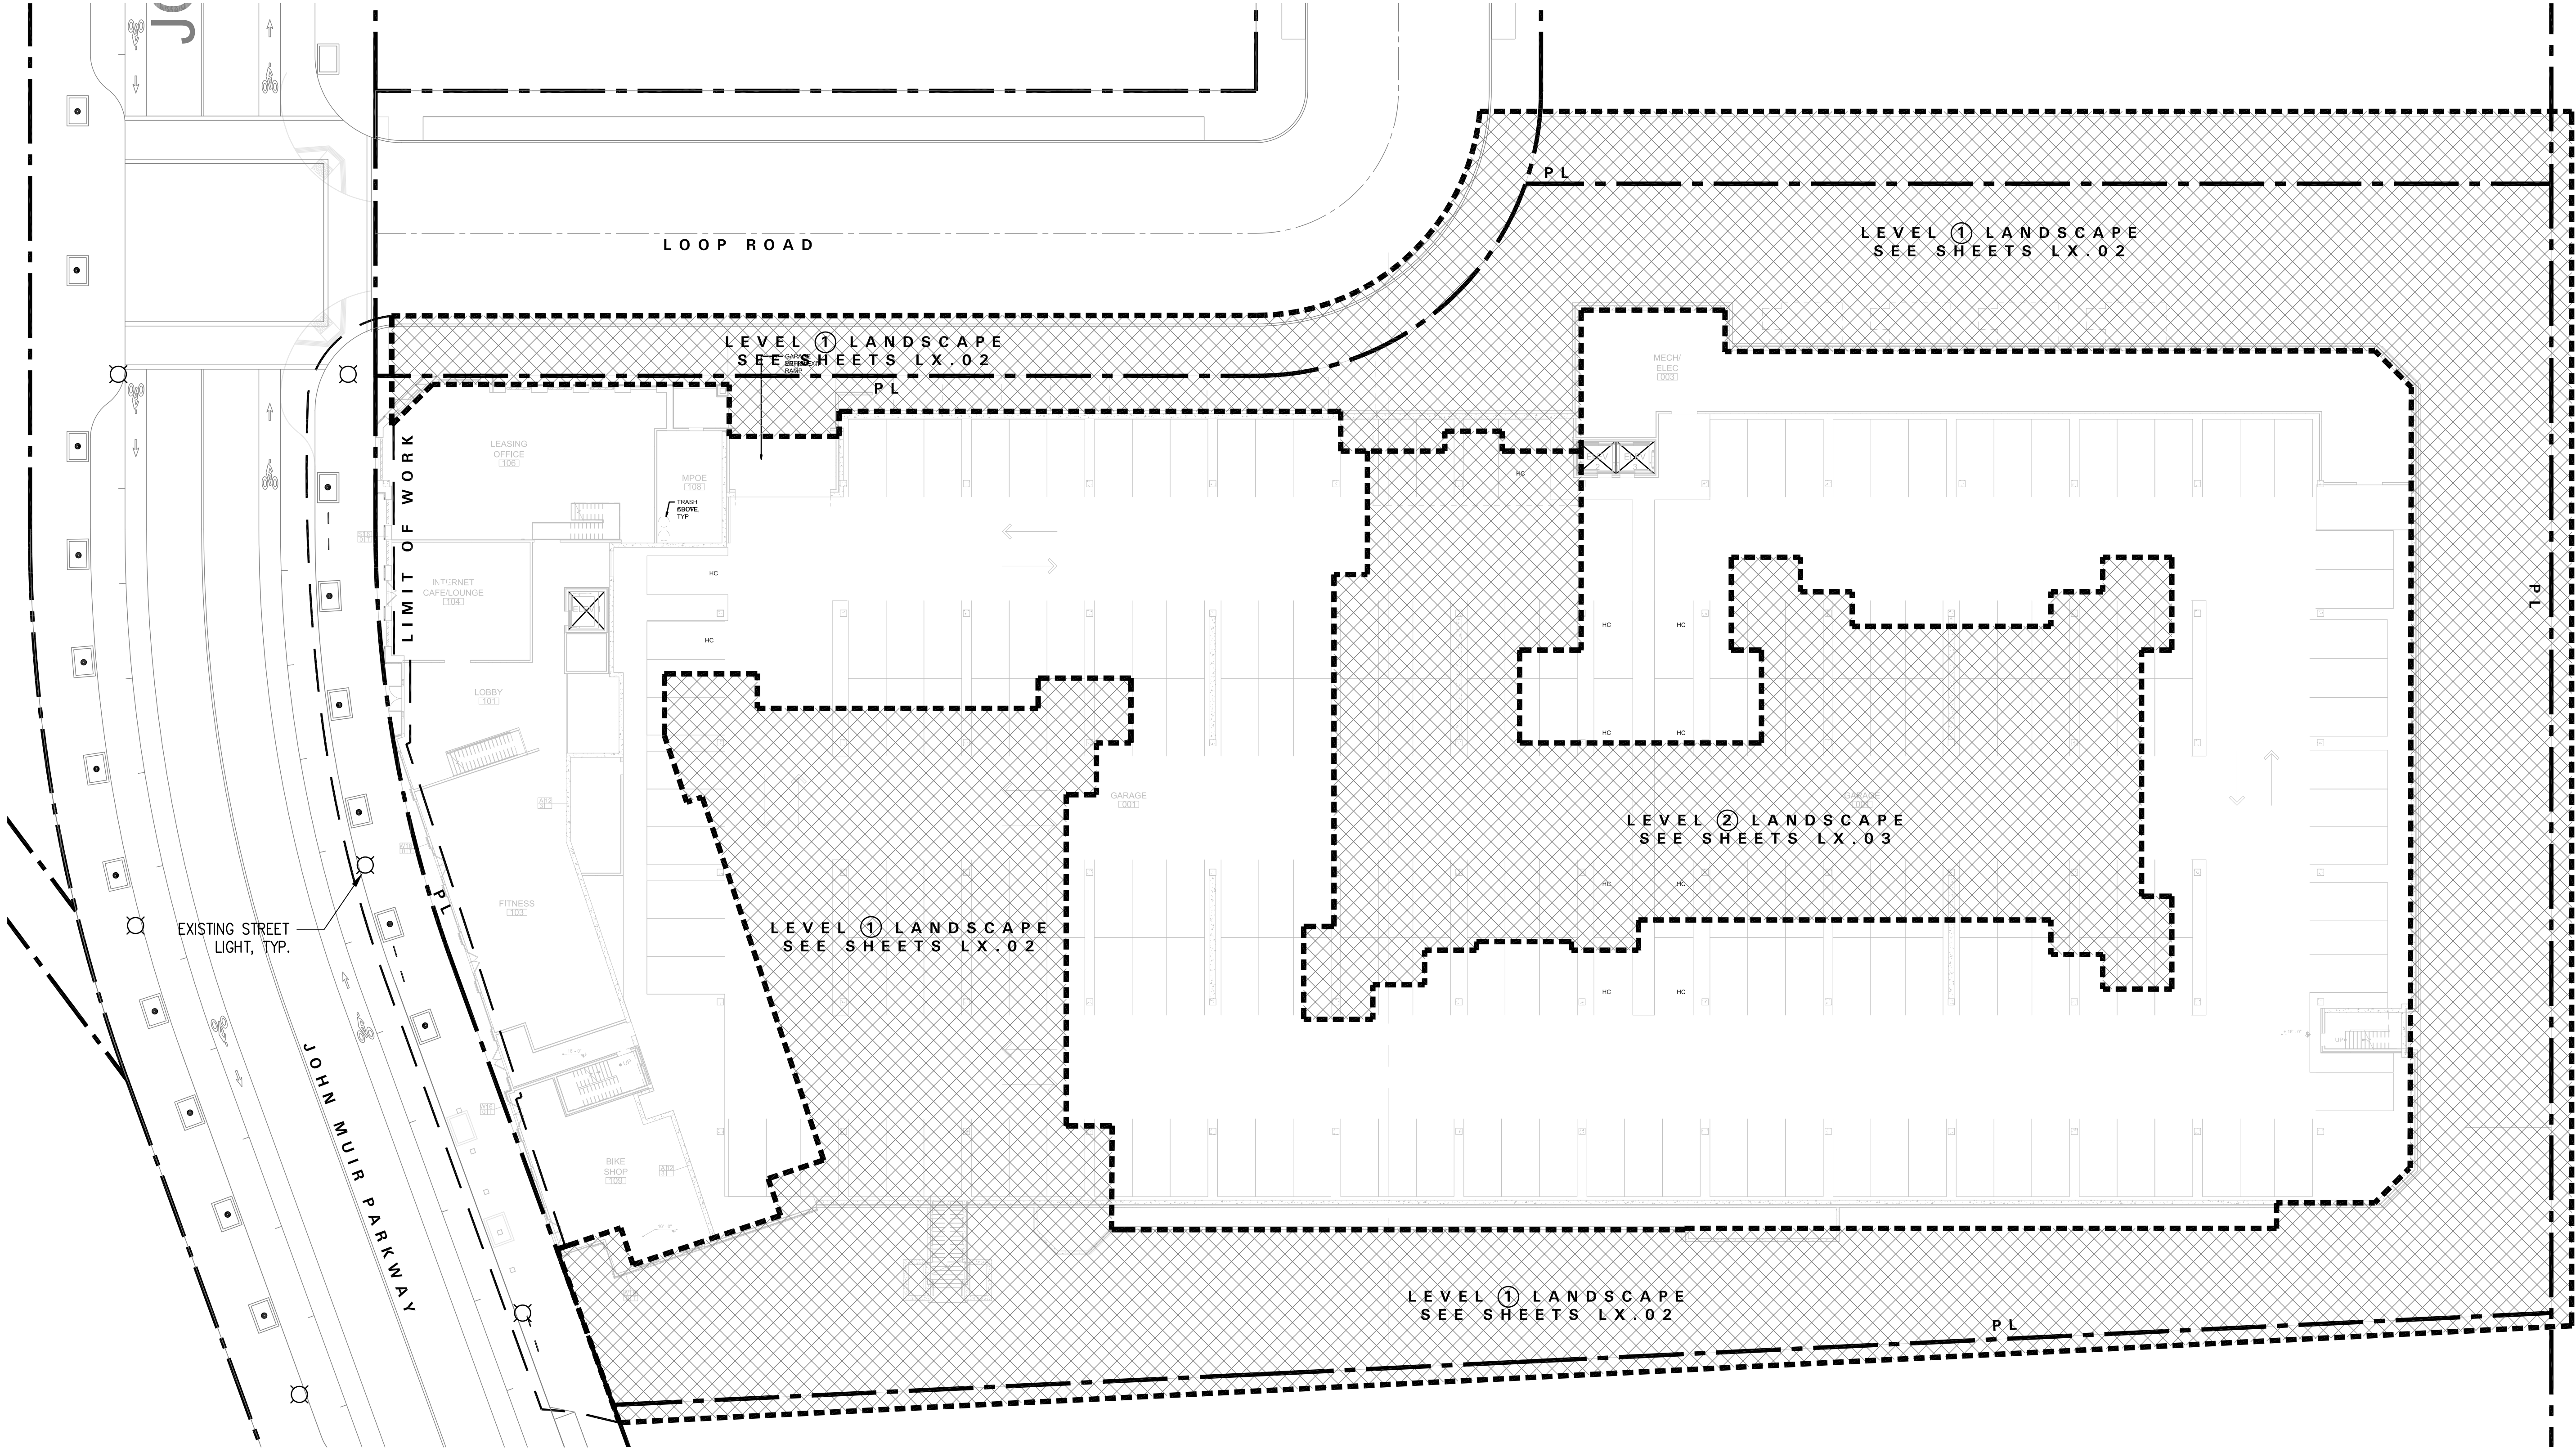

HERCULES PARCELS Q & R


HERCULES, CA

LIGHTING PLAN-STREET LEVEL

swa
301 Battery Street
2 Mezzanine
San Francisco, California
94111-3212
United States
www.swagroup.com
+1.415.836.8770 o


BARS705

03.06.2018

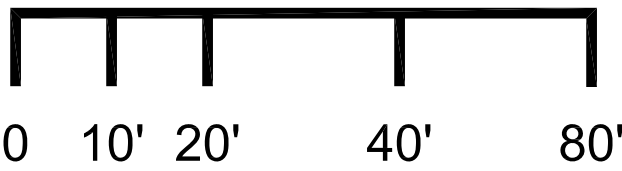

LANDSCAPE
L3.01

[FILE NAME: Z:\17025 HERCULES PARCELS Q+R\6 DRAWING\6.40 CAD\1-SITE\170254 BLOCK Q+R_TNDWG] [TAB: 34X22 BLDG SECTIONS + TITLE BLOCK] [October 18 - Wednesday 2017 - 6:14pm] [Plotted by: TNGUYEN] [Pen Setting: {Unknown}]
[XREF FILE NAME: -HBCX_TWBDY; -HBCX_SITE; -HBCX_TOPO; -HBCX_UTIL; -HERCULES_MURPOINT_LAYOUT; -JMPPPLAN; -JMPPRUTIL; UNIT 1A; UNIT 1B; UNIT 1E; UNIT 1R A; UNIT 1R B; UNIT 2A; UNIT 2B; UNIT 2C; UNIT 2C MOD 1; UNIT 2D; UNIT 2F; UNIT 3A; W3422PER; W3422PERLOG]

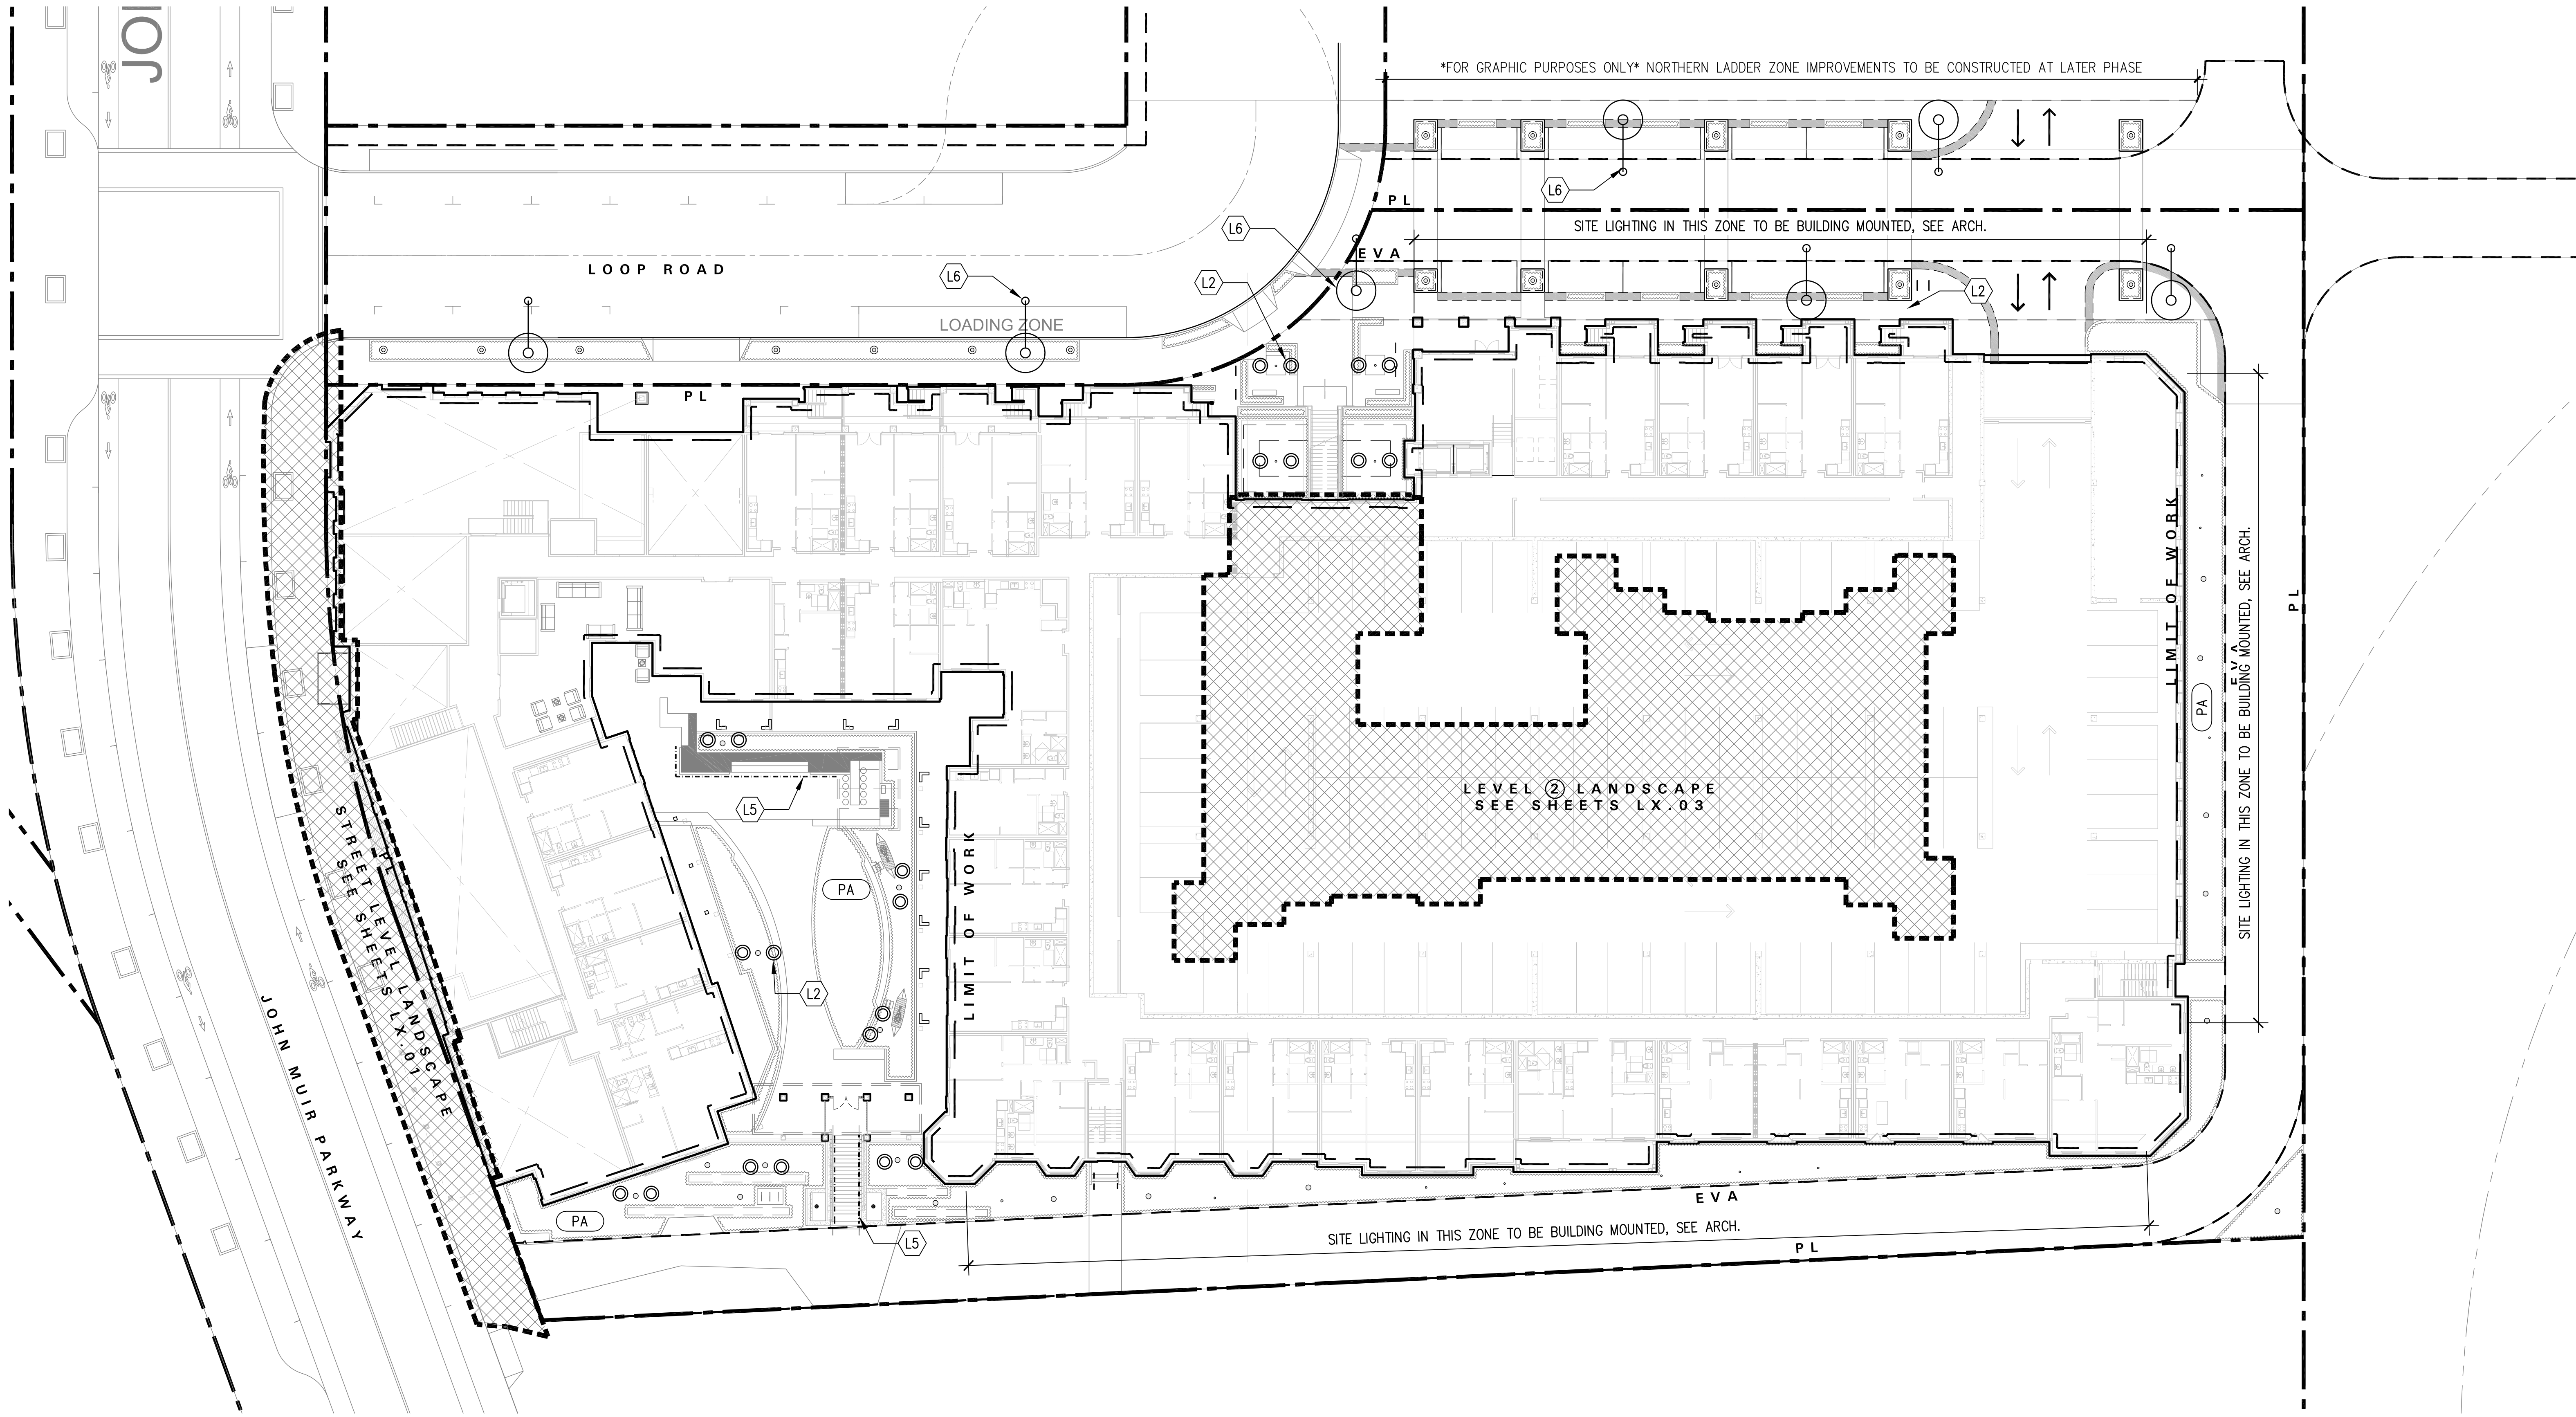

HERCULES PARCELS Q & R

HERCULES, CA


LIGHTING PLAN LEVEL 1

[illegible]


HERCULES, CA

LIGHTING PLAN LEVEL 2

 LANDSCAPE
L3.03

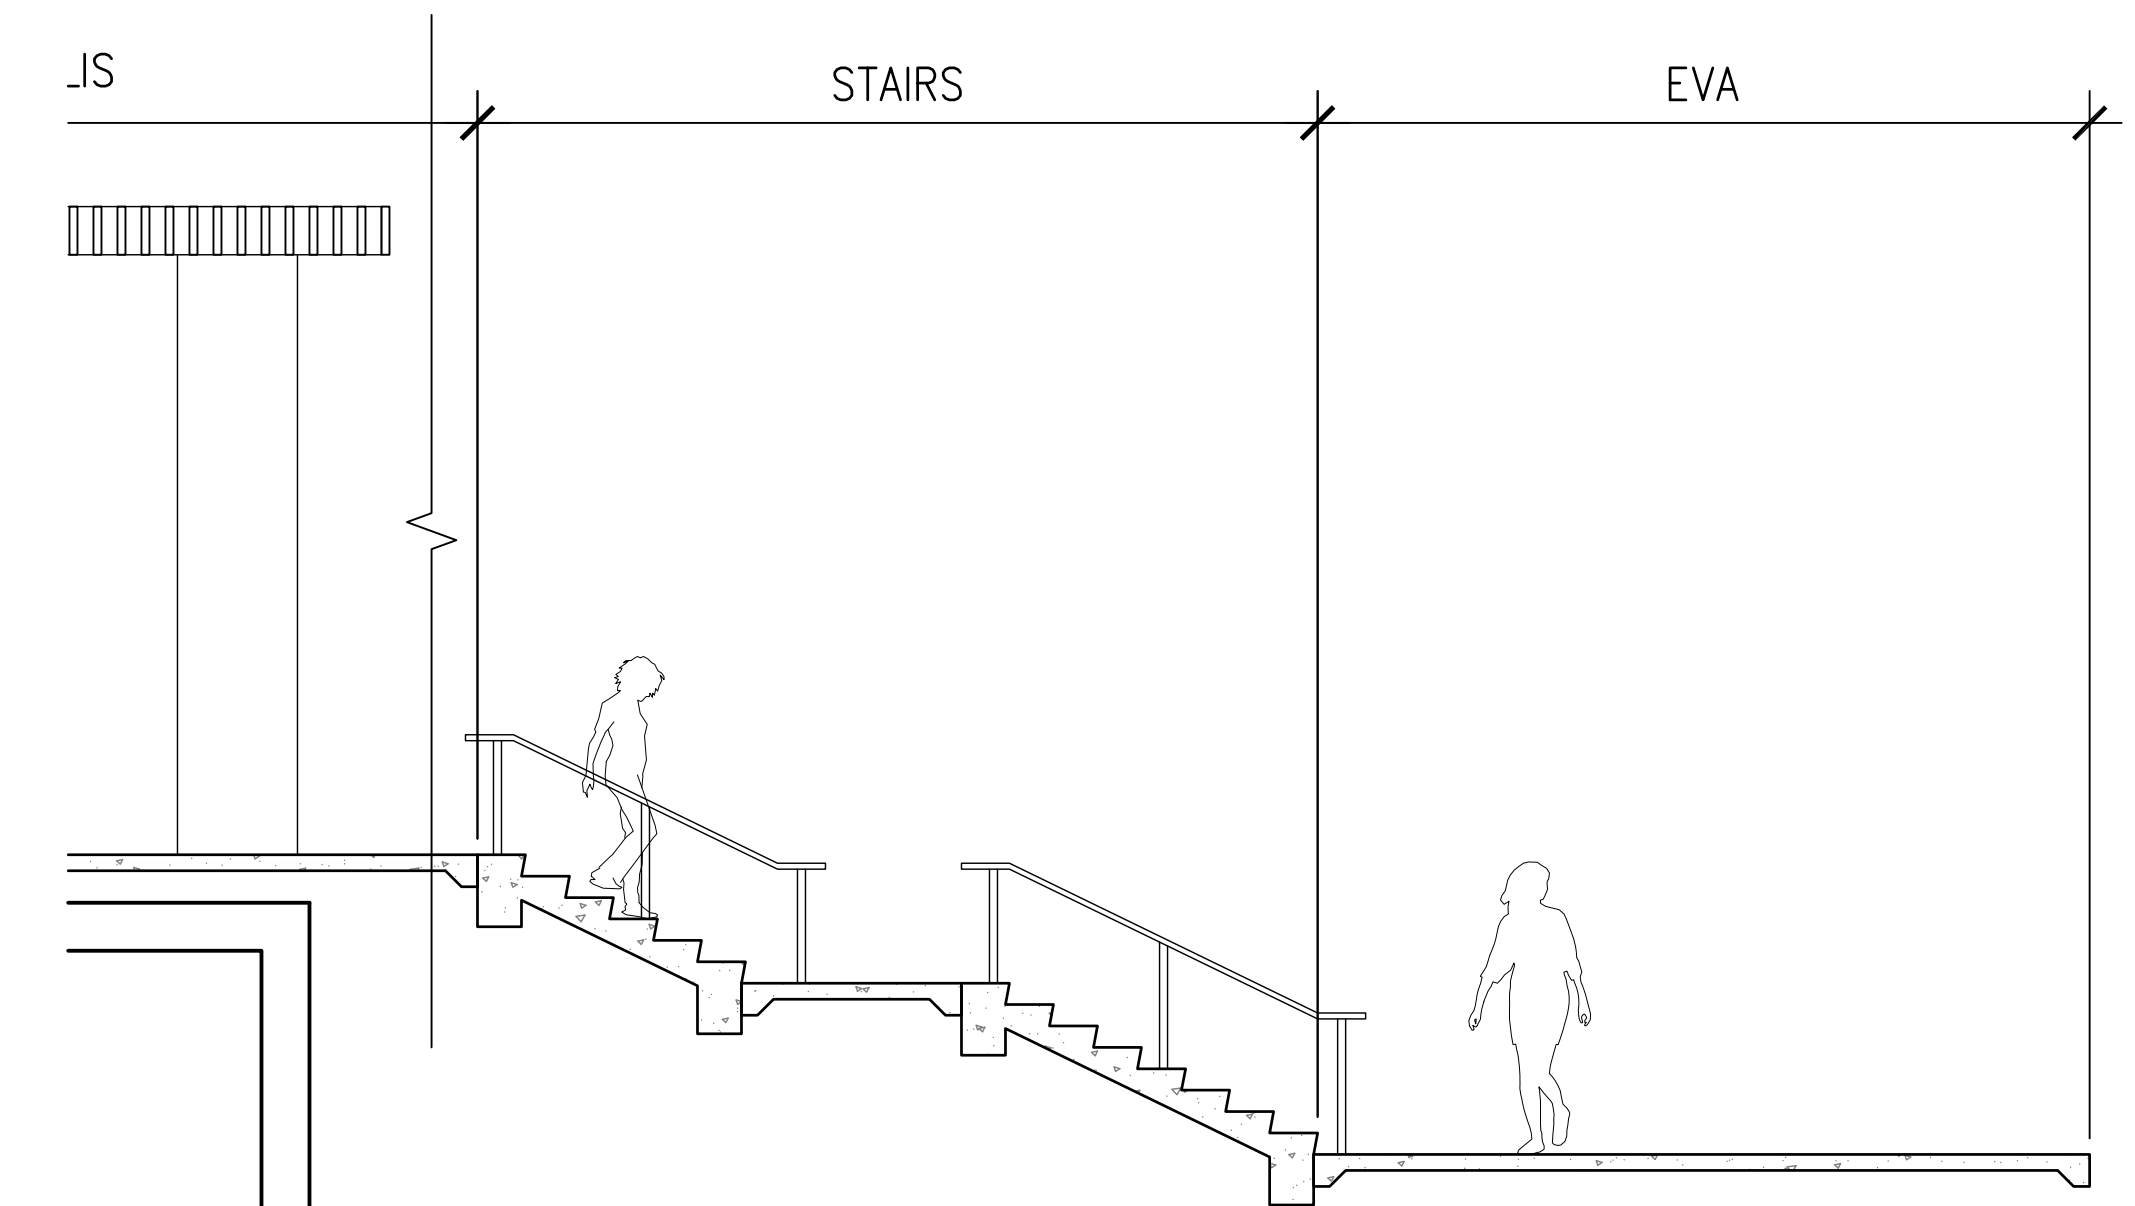


01 LOWER PODIUM – SECTION 1 B
1/4" = 1'-0"

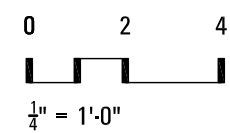

HERCULES, CA

LOWER PODIUM SECTIONS

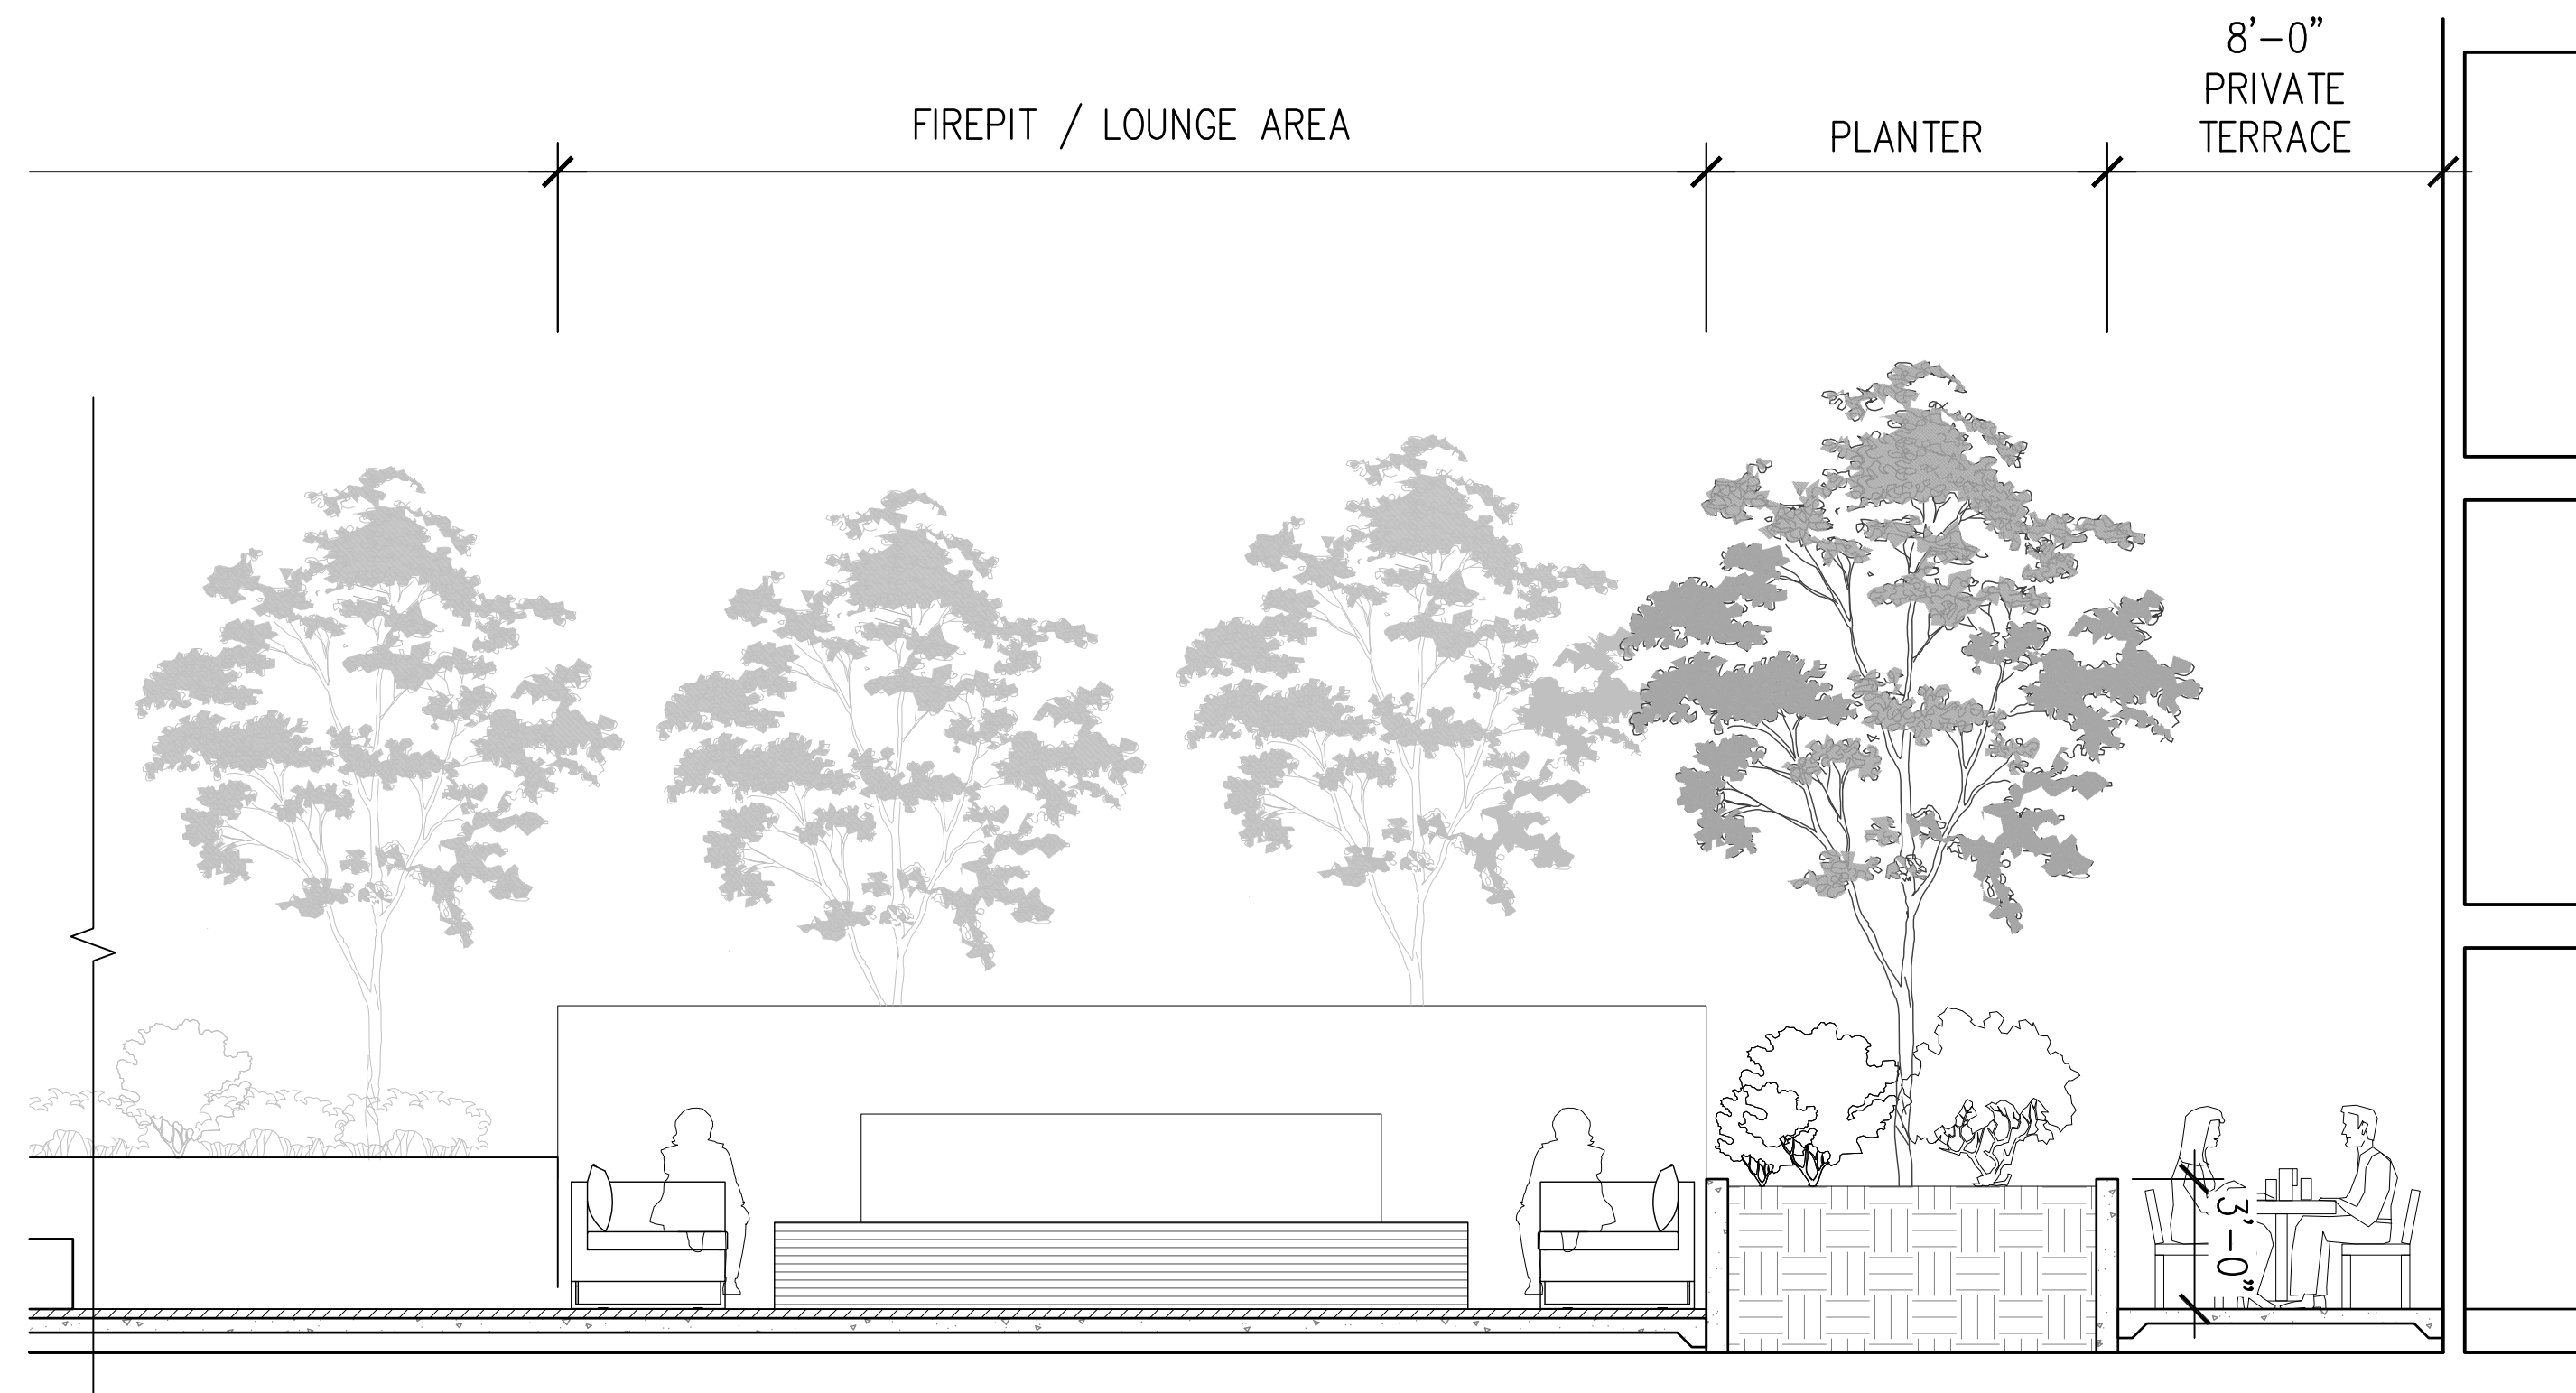






01 UPPER PODIUM - SECTION 1B
1/4" = 1'-0"



01 UPPER PODIUM - SECTION 1A
1/4" = 1'-0"

HERCULES, CA

UPPER PODIUM SECTIONS

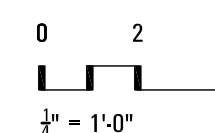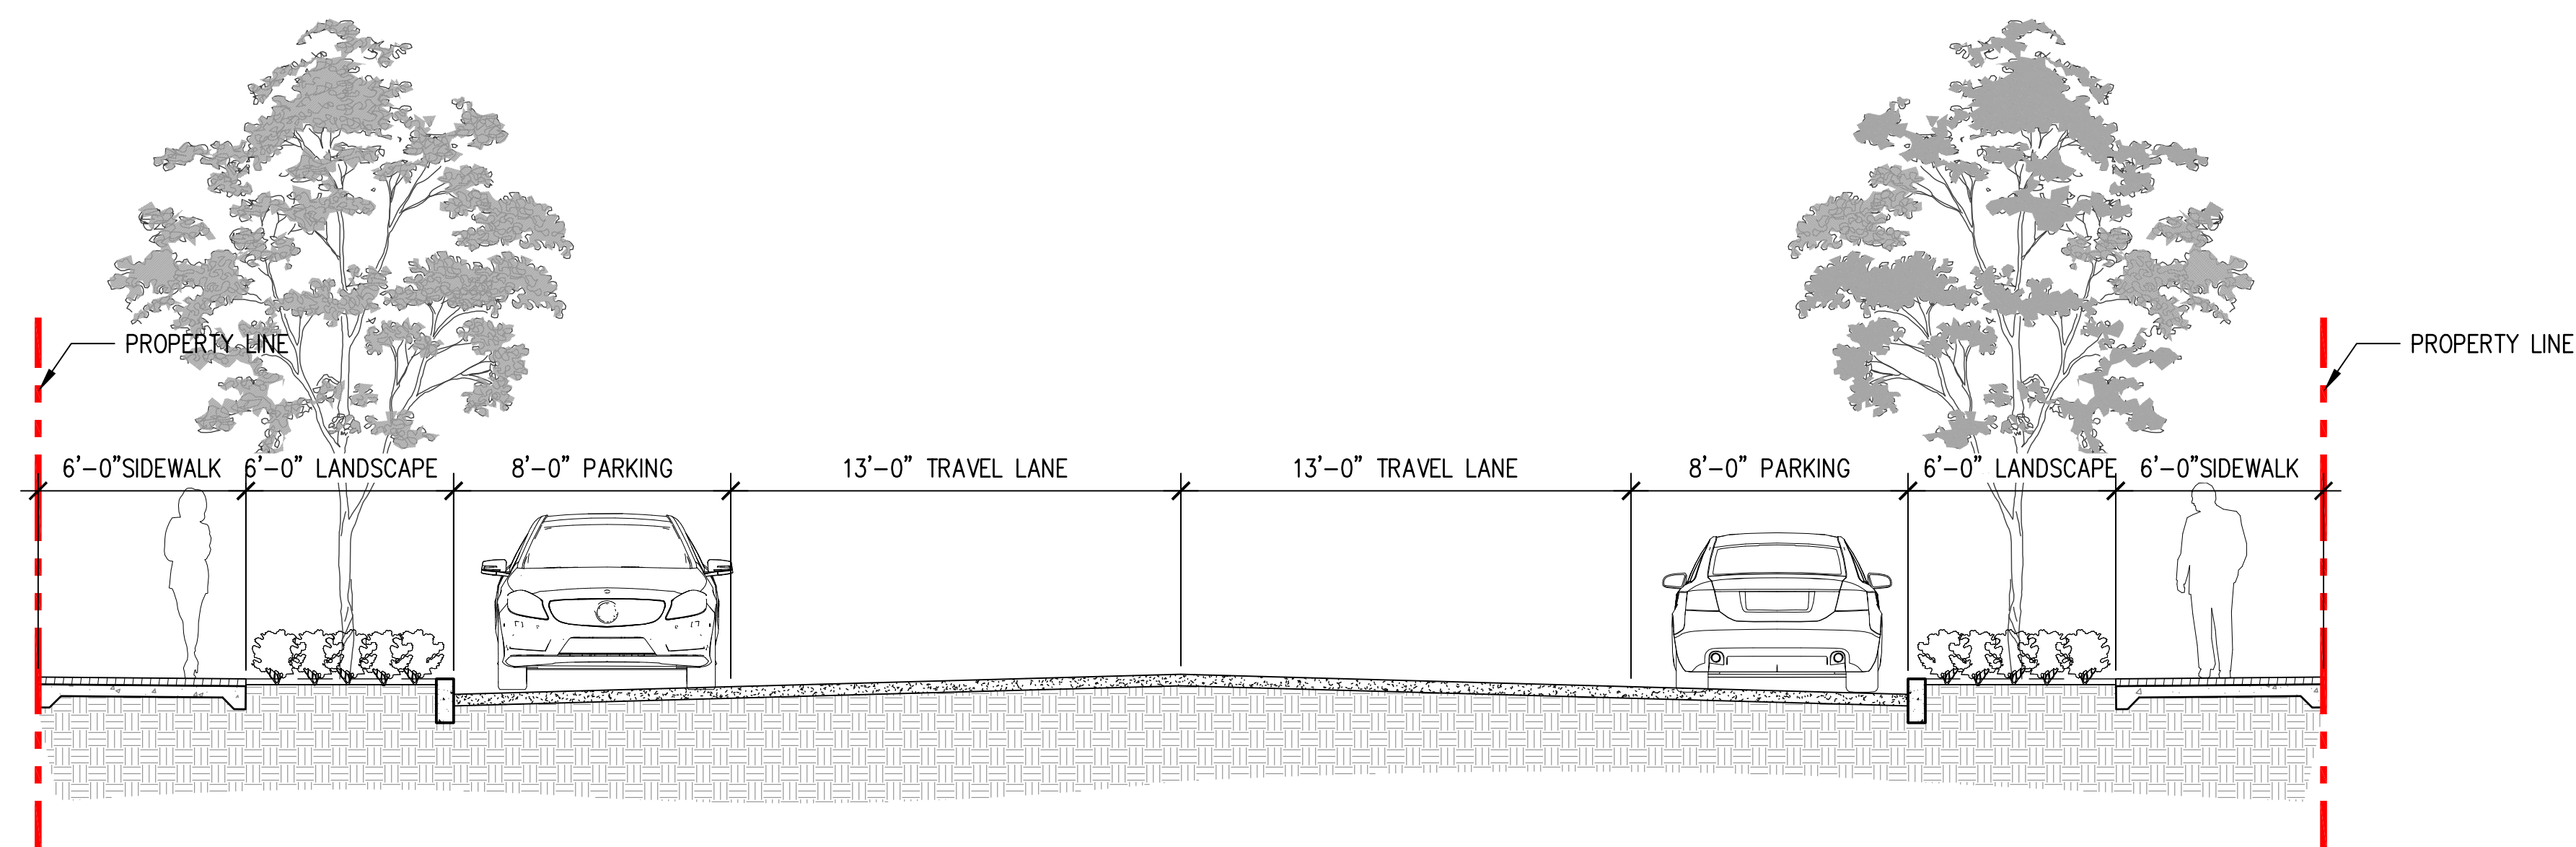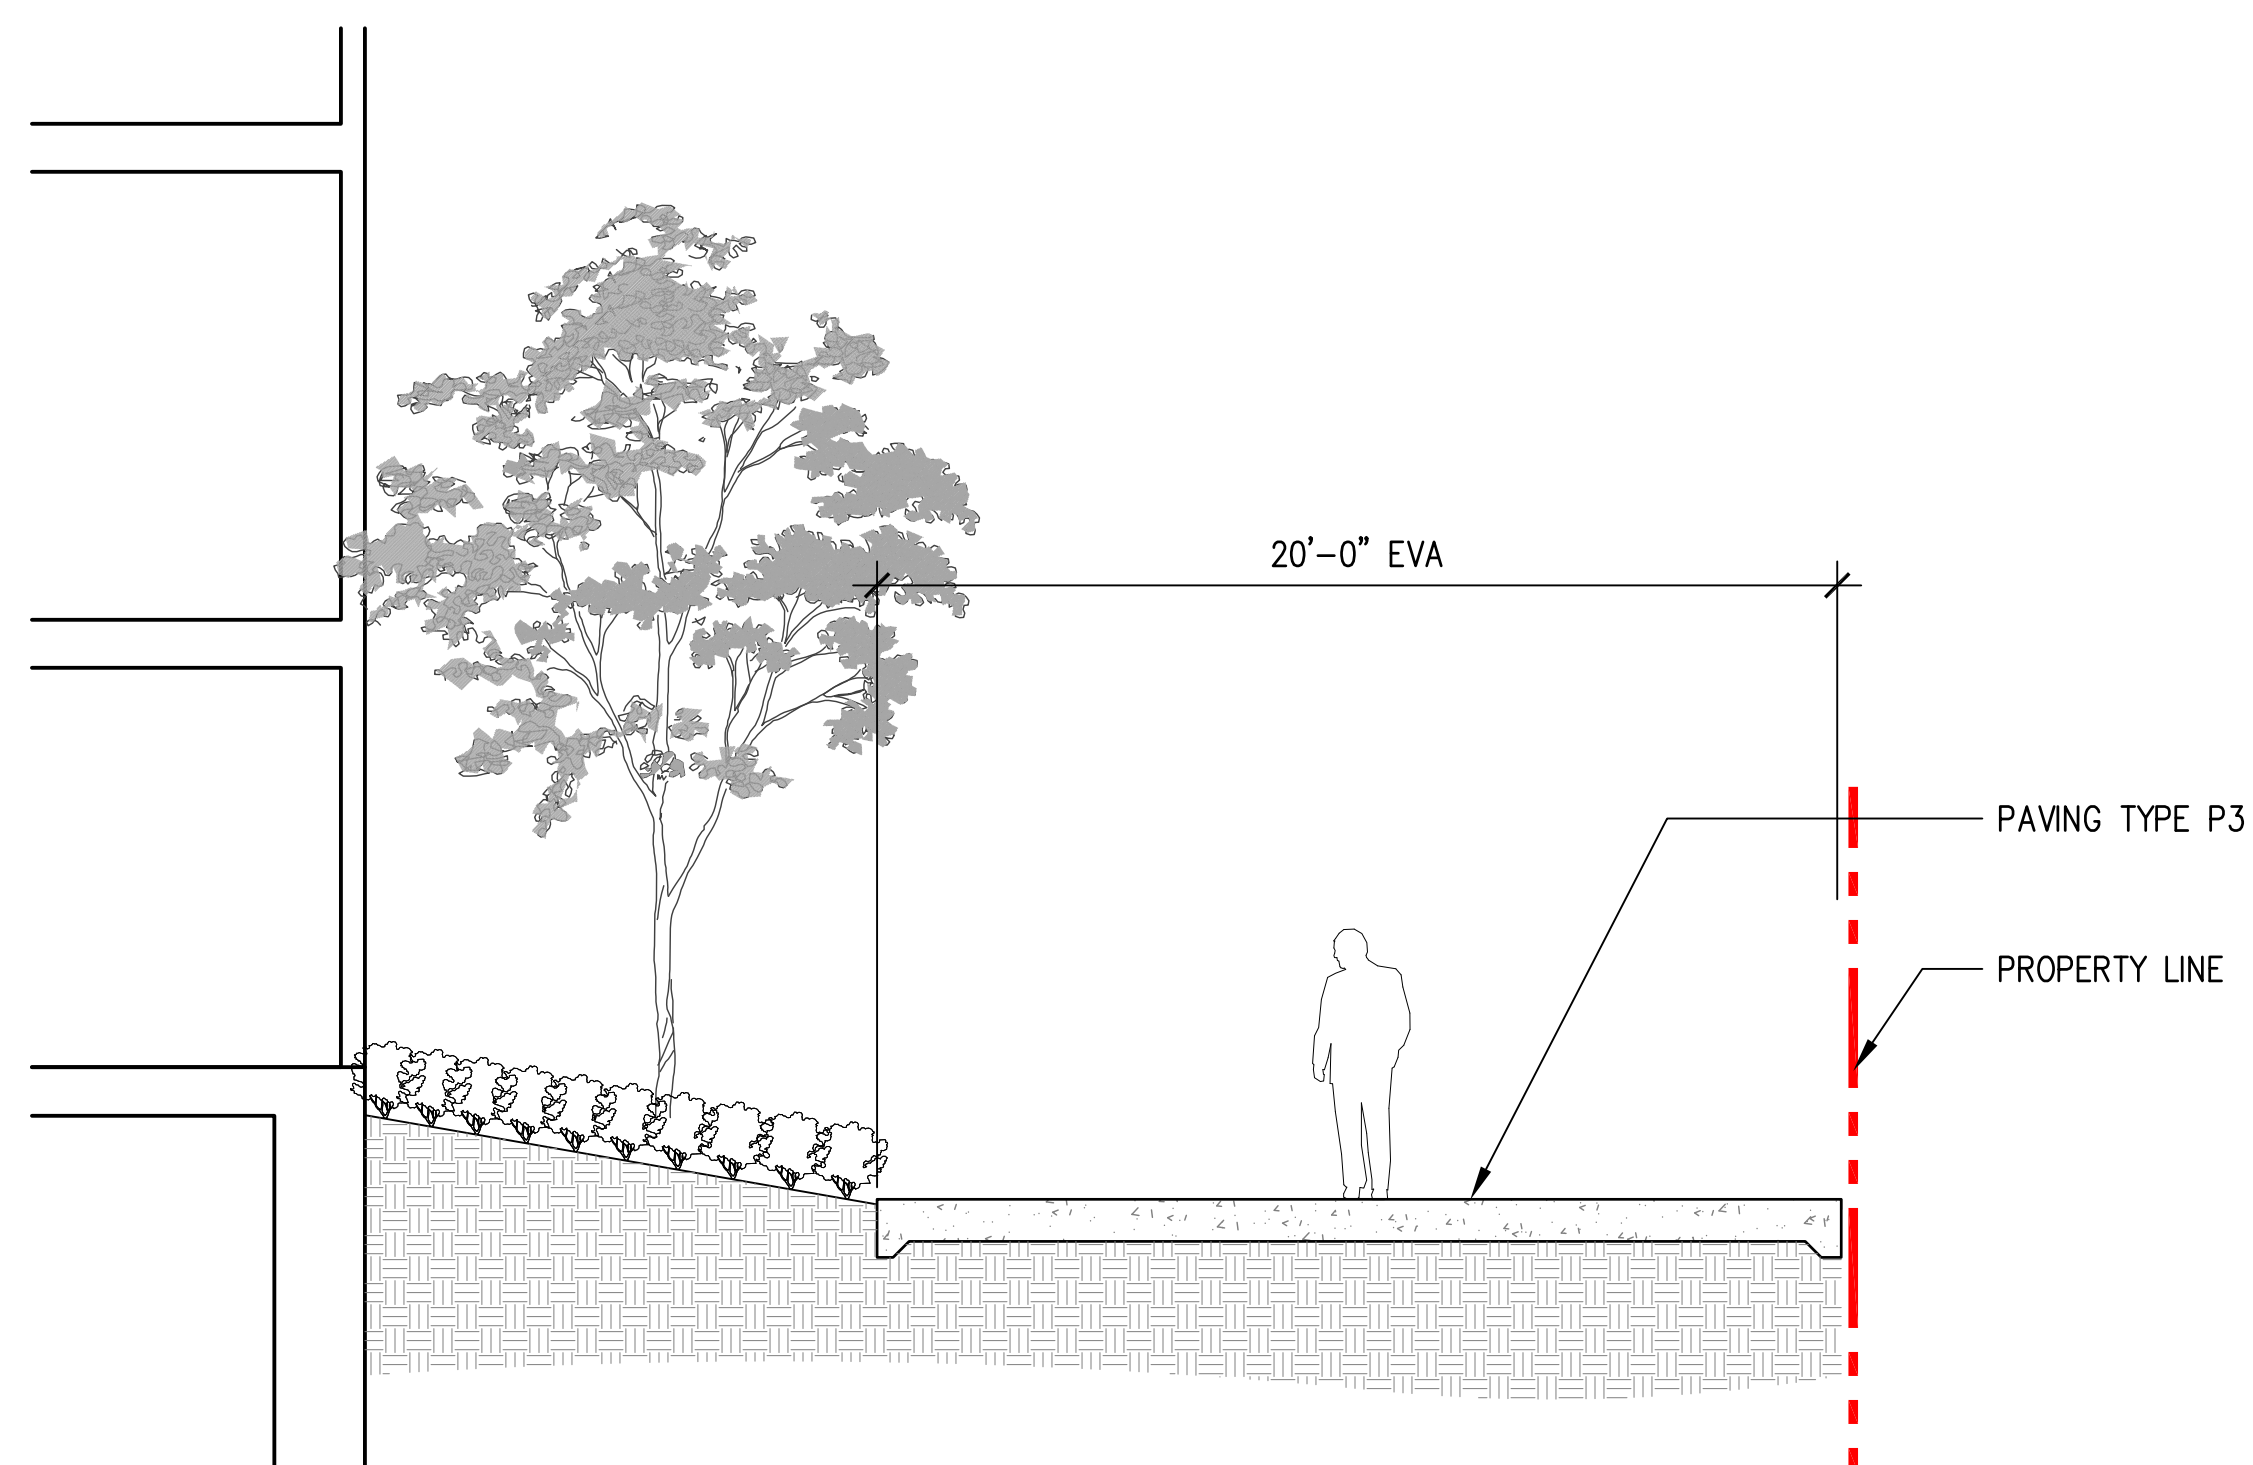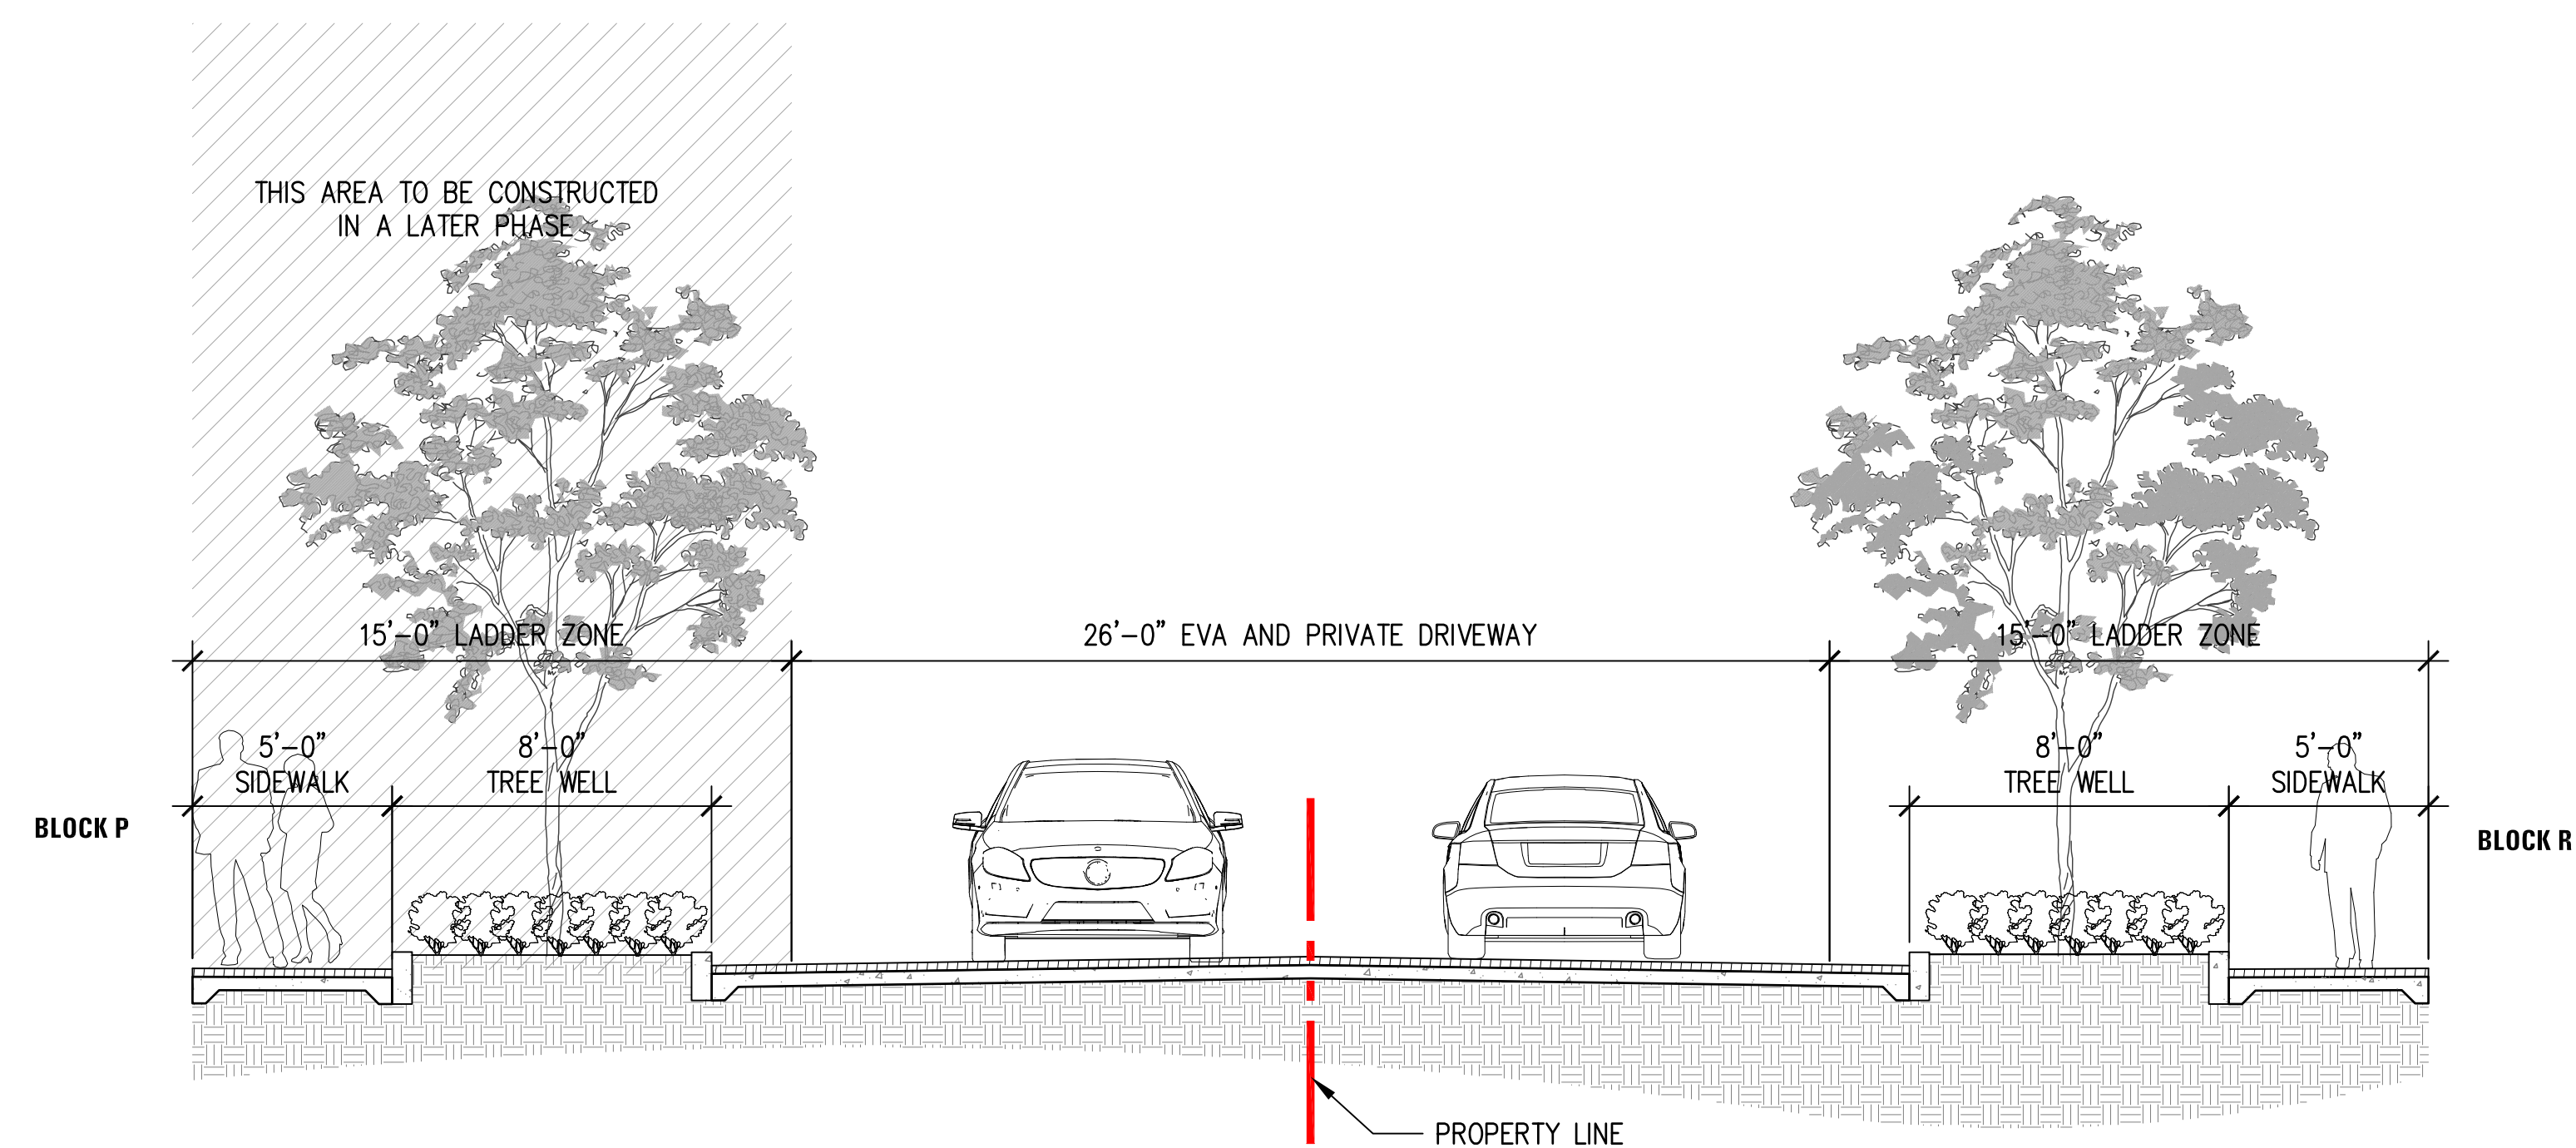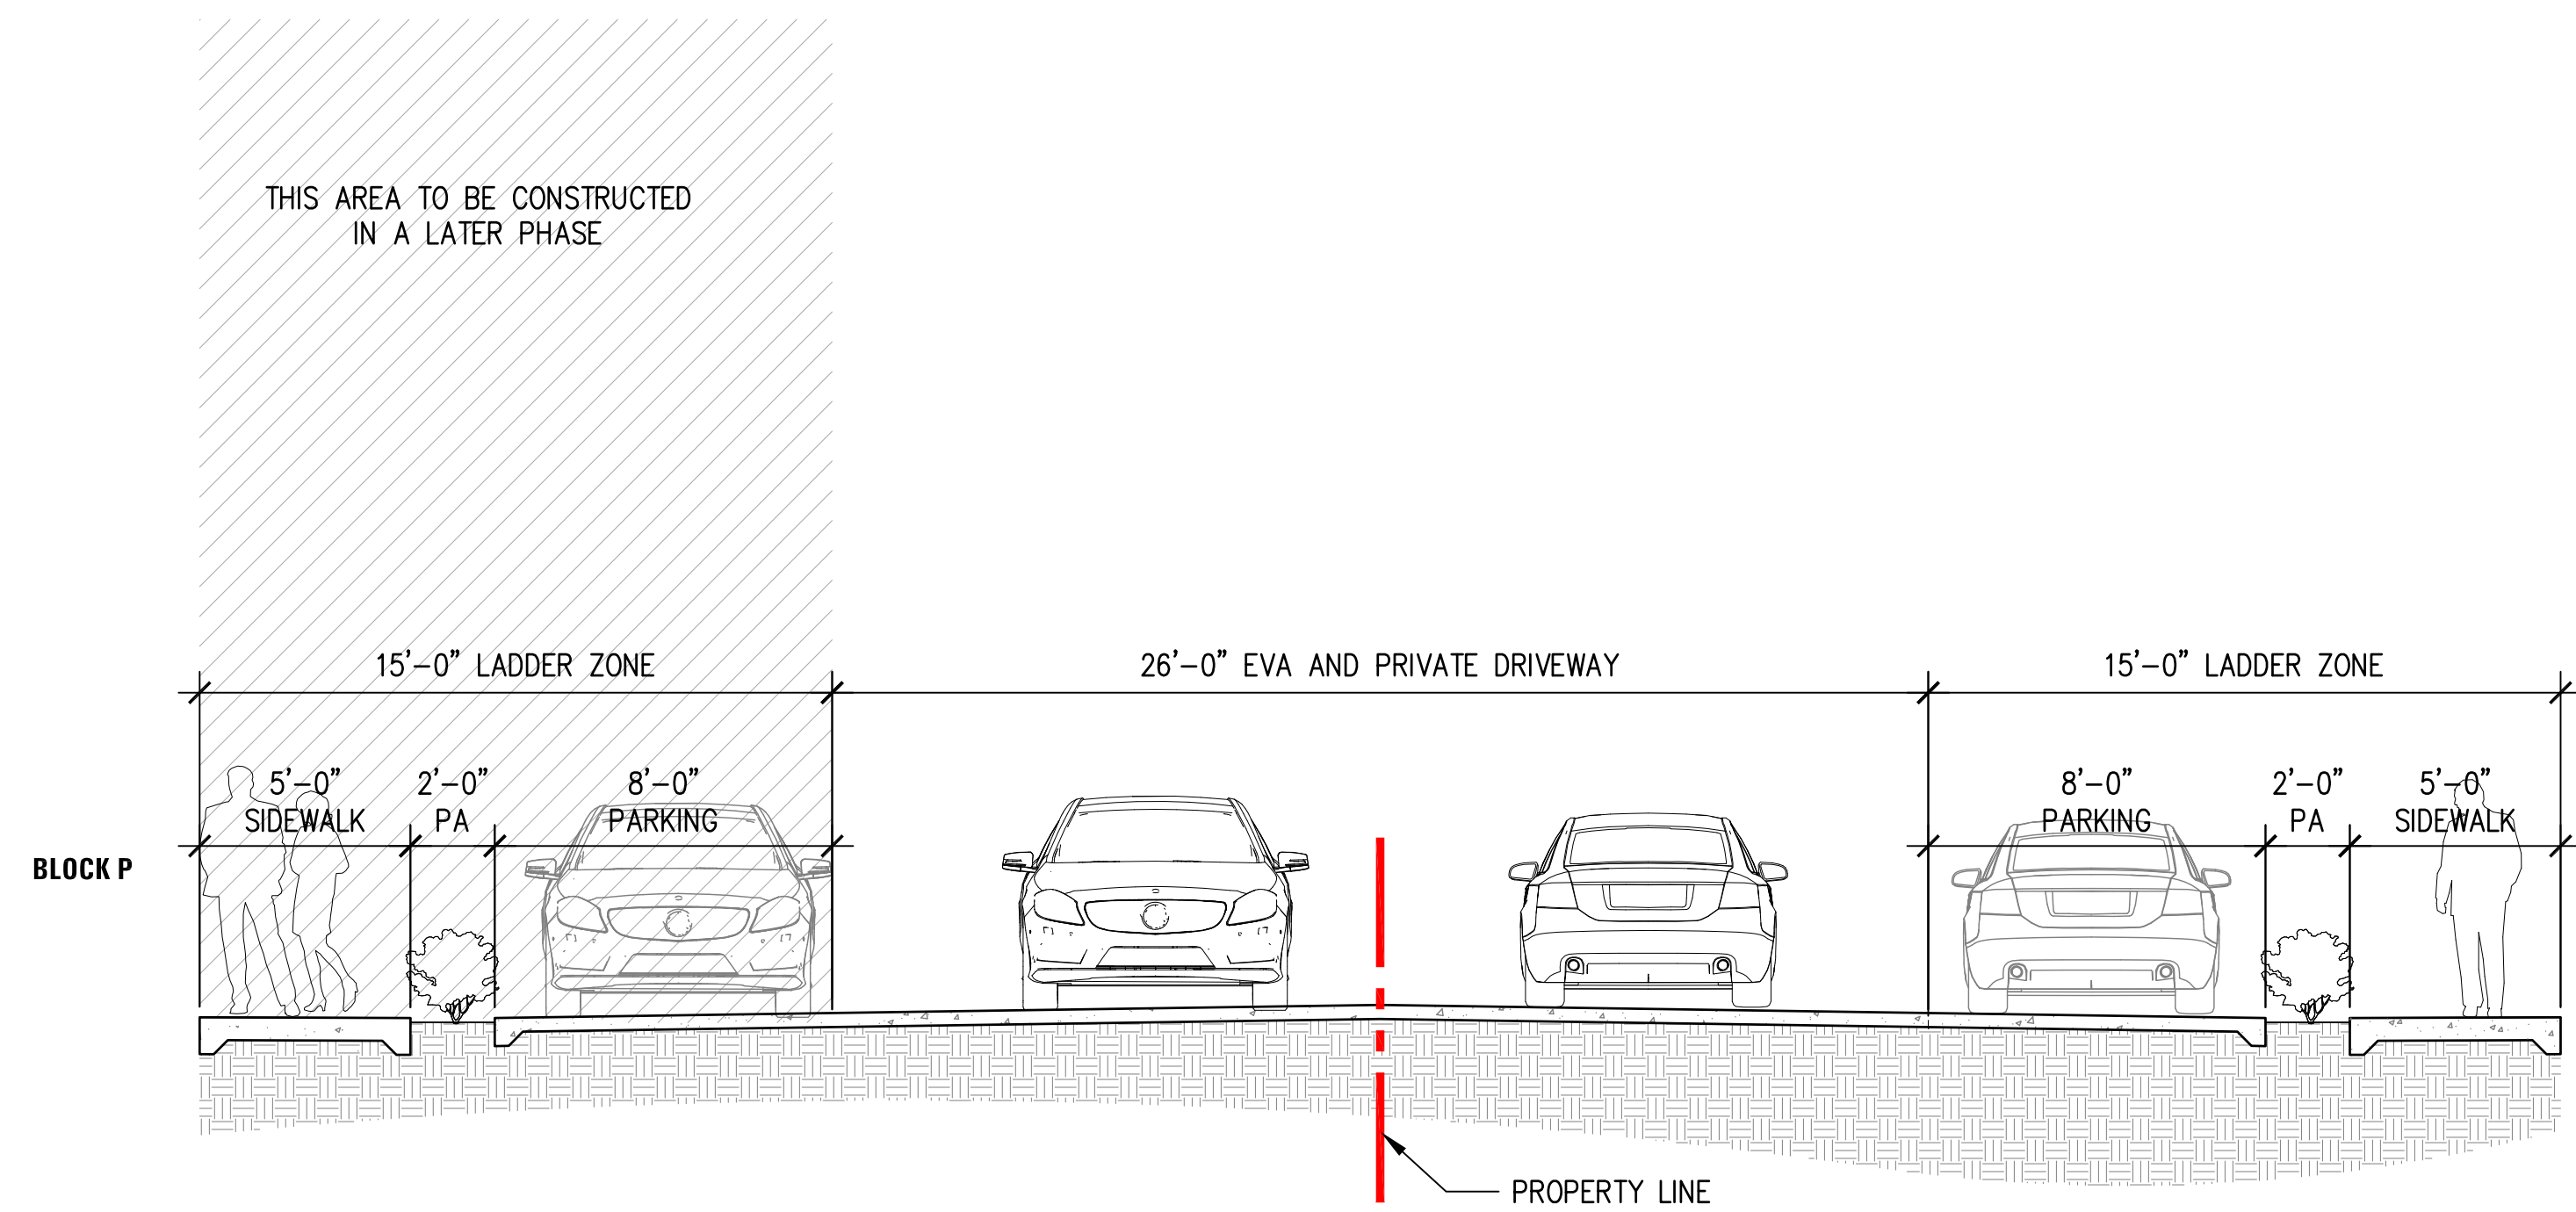

[FILE NAME: Z:\17025 HERCULES PARCELS Q&R6 DRAWING\6.40 CAD\1-SITE\170254_BLOCK Q-R_TNDWG3] [TAB: 34X22 BLDG SECTIONS + TITLE BLOCK] [October 18 - Wednesday 2017 - 6:14pm] [Plotted by: TNGUYEN] [Pen Setting: (Unknown)]
[XREF FILE NAME: -HBEX_TWBODY: -HBEXSITE: -HBEXTOPD: -HBEXUTIL: -HERCULES_MUIRPOINTE_LAYOUT: -JMPPRPLAN: -JMPPRUTIL: UNIT 1A: UNIT 1B: UNIT 1E: UNIT 1R A: UNIT 1R B: UNIT 2A: UNIT 2B: UNIT 2C: UNIT 2C MOD 1: UNIT 2D: UNIT 2F: UNIT 2G: UNIT 3A: W3422PER: W3422PERLOG]

HERCULES PARCELS Q & R


HERCULES, CA

ENLARGEMENT PLAN-LOWER PODIUM


swa
301 Battery Street
2 Mezzanine
San Francisco, California
94111-3212
United States
www.swagroup.com
+1.415.836.8770 o

BARS705


03.06.2018

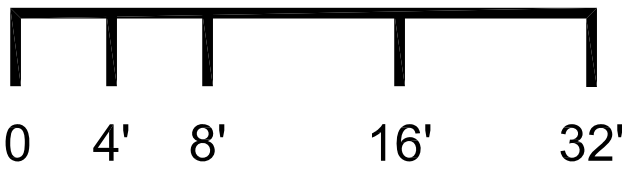

LANDSCAPE
L6.01

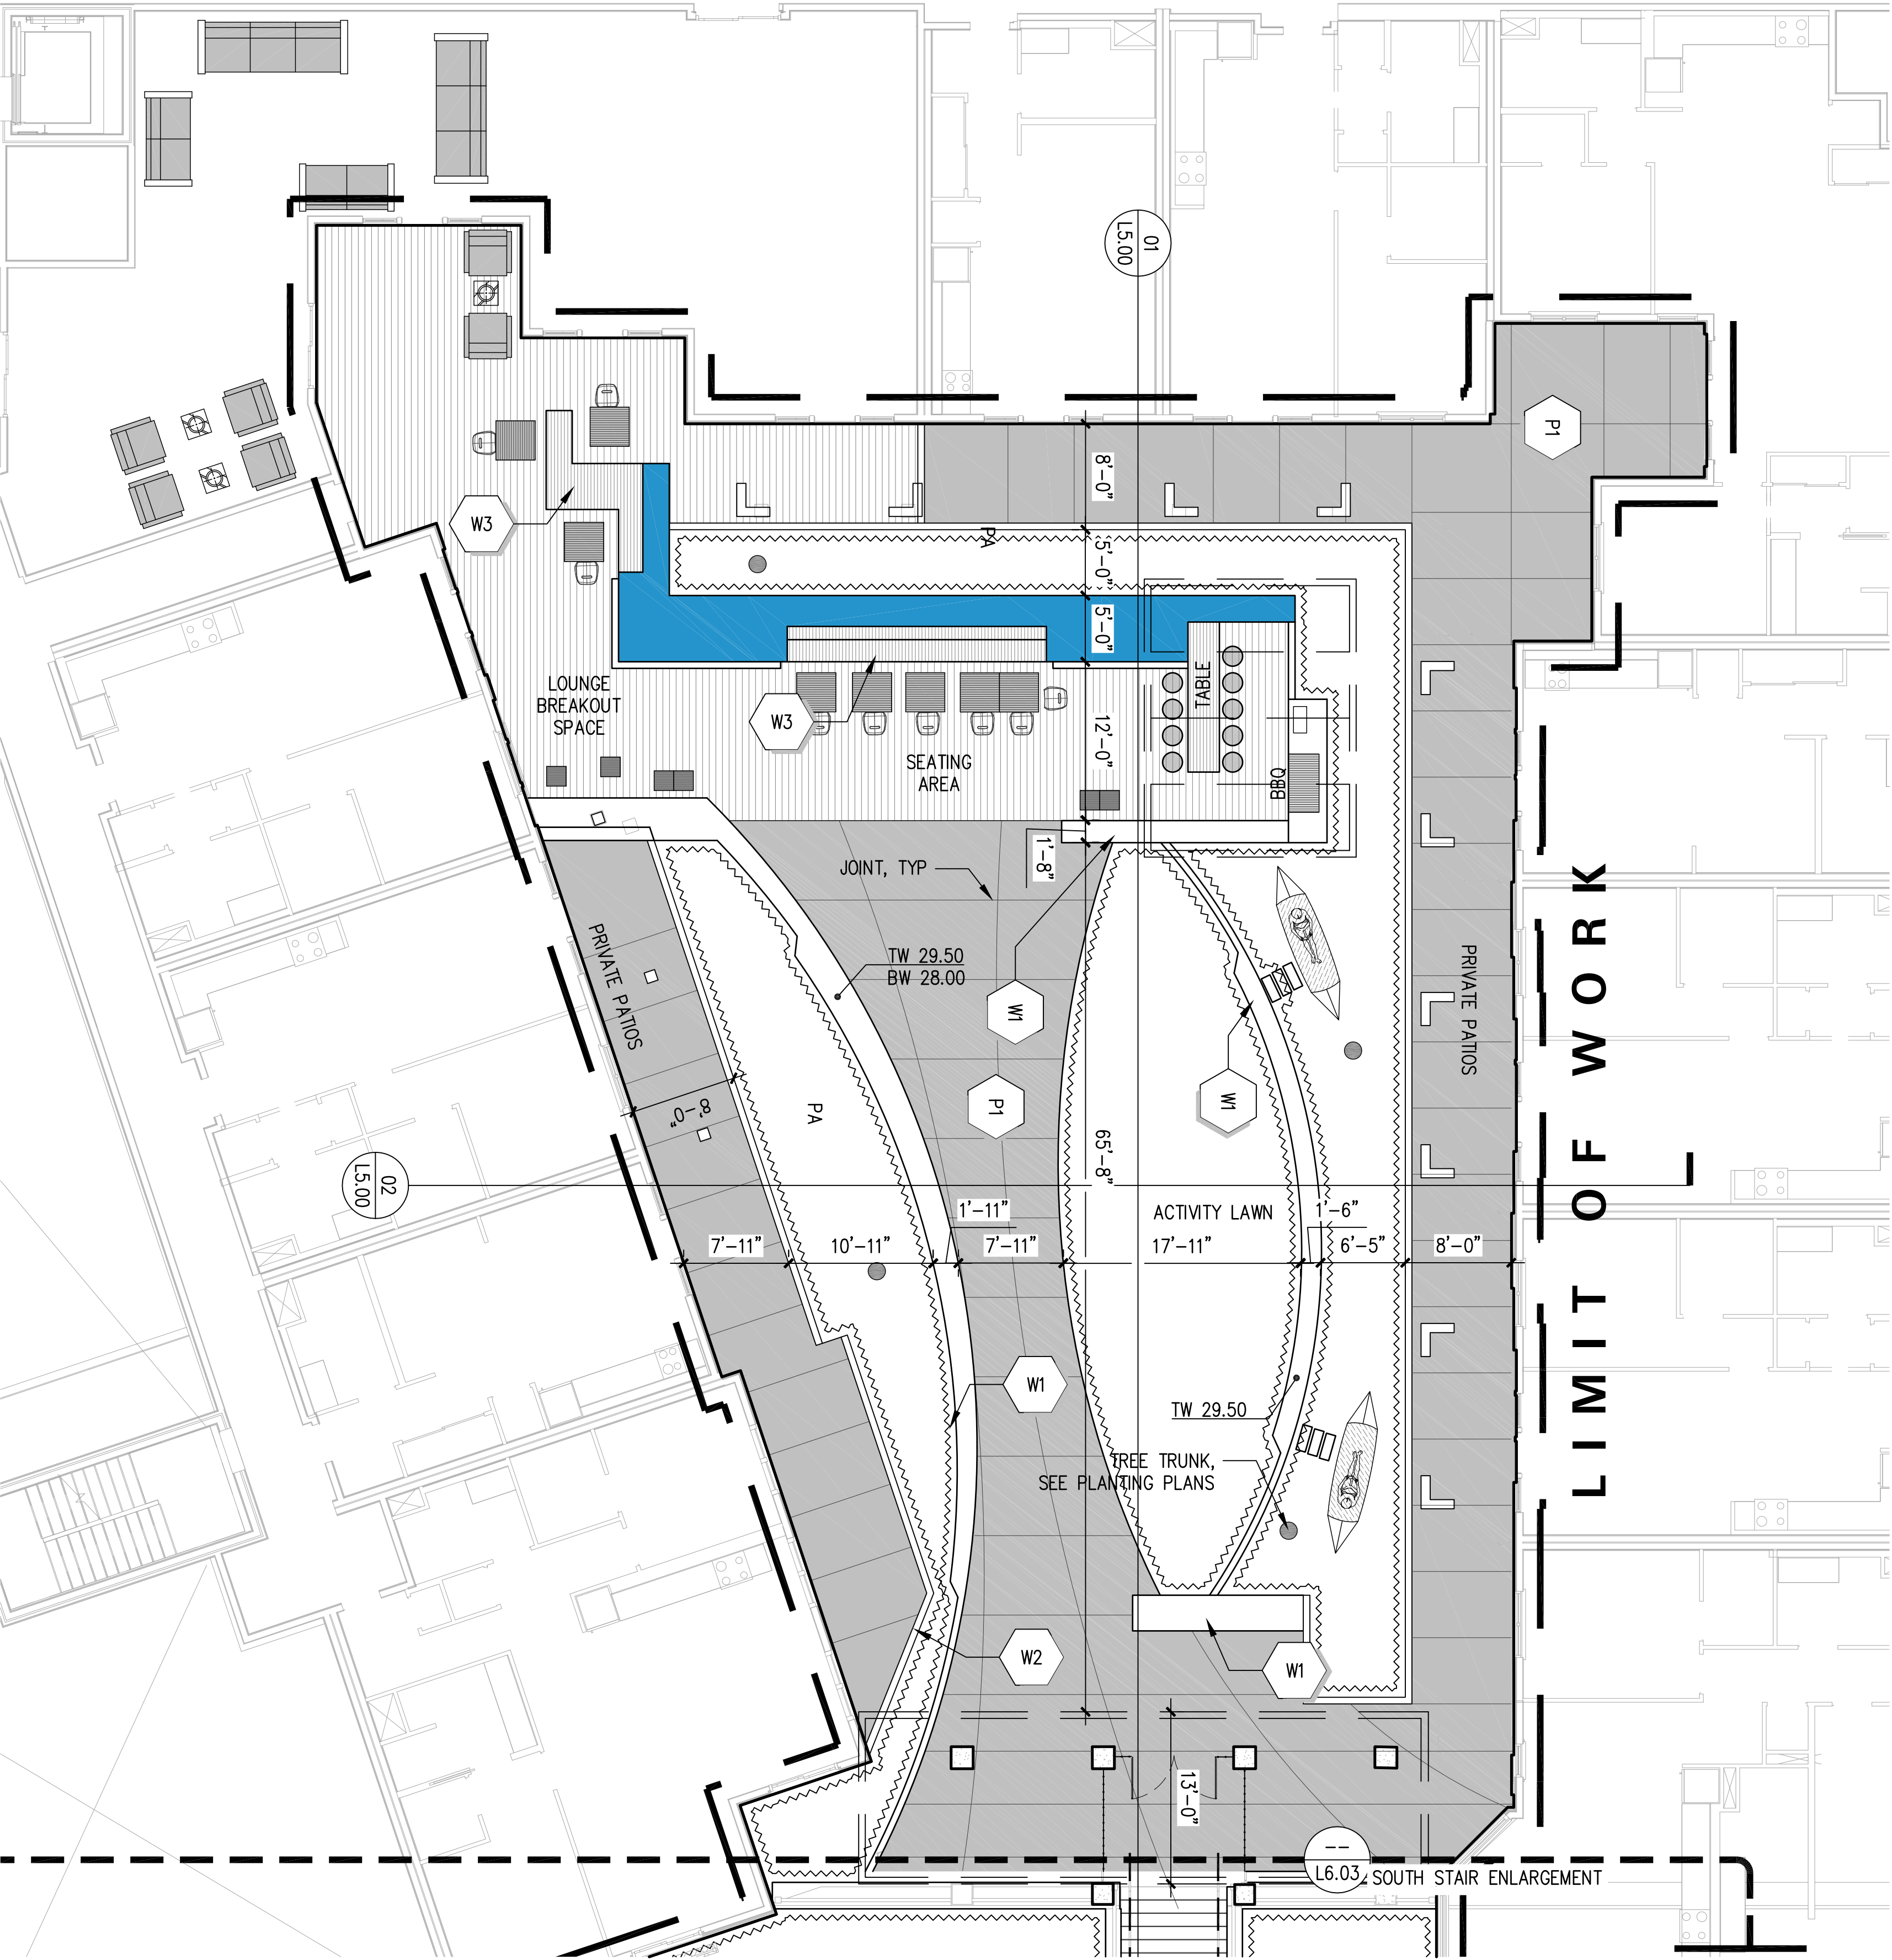



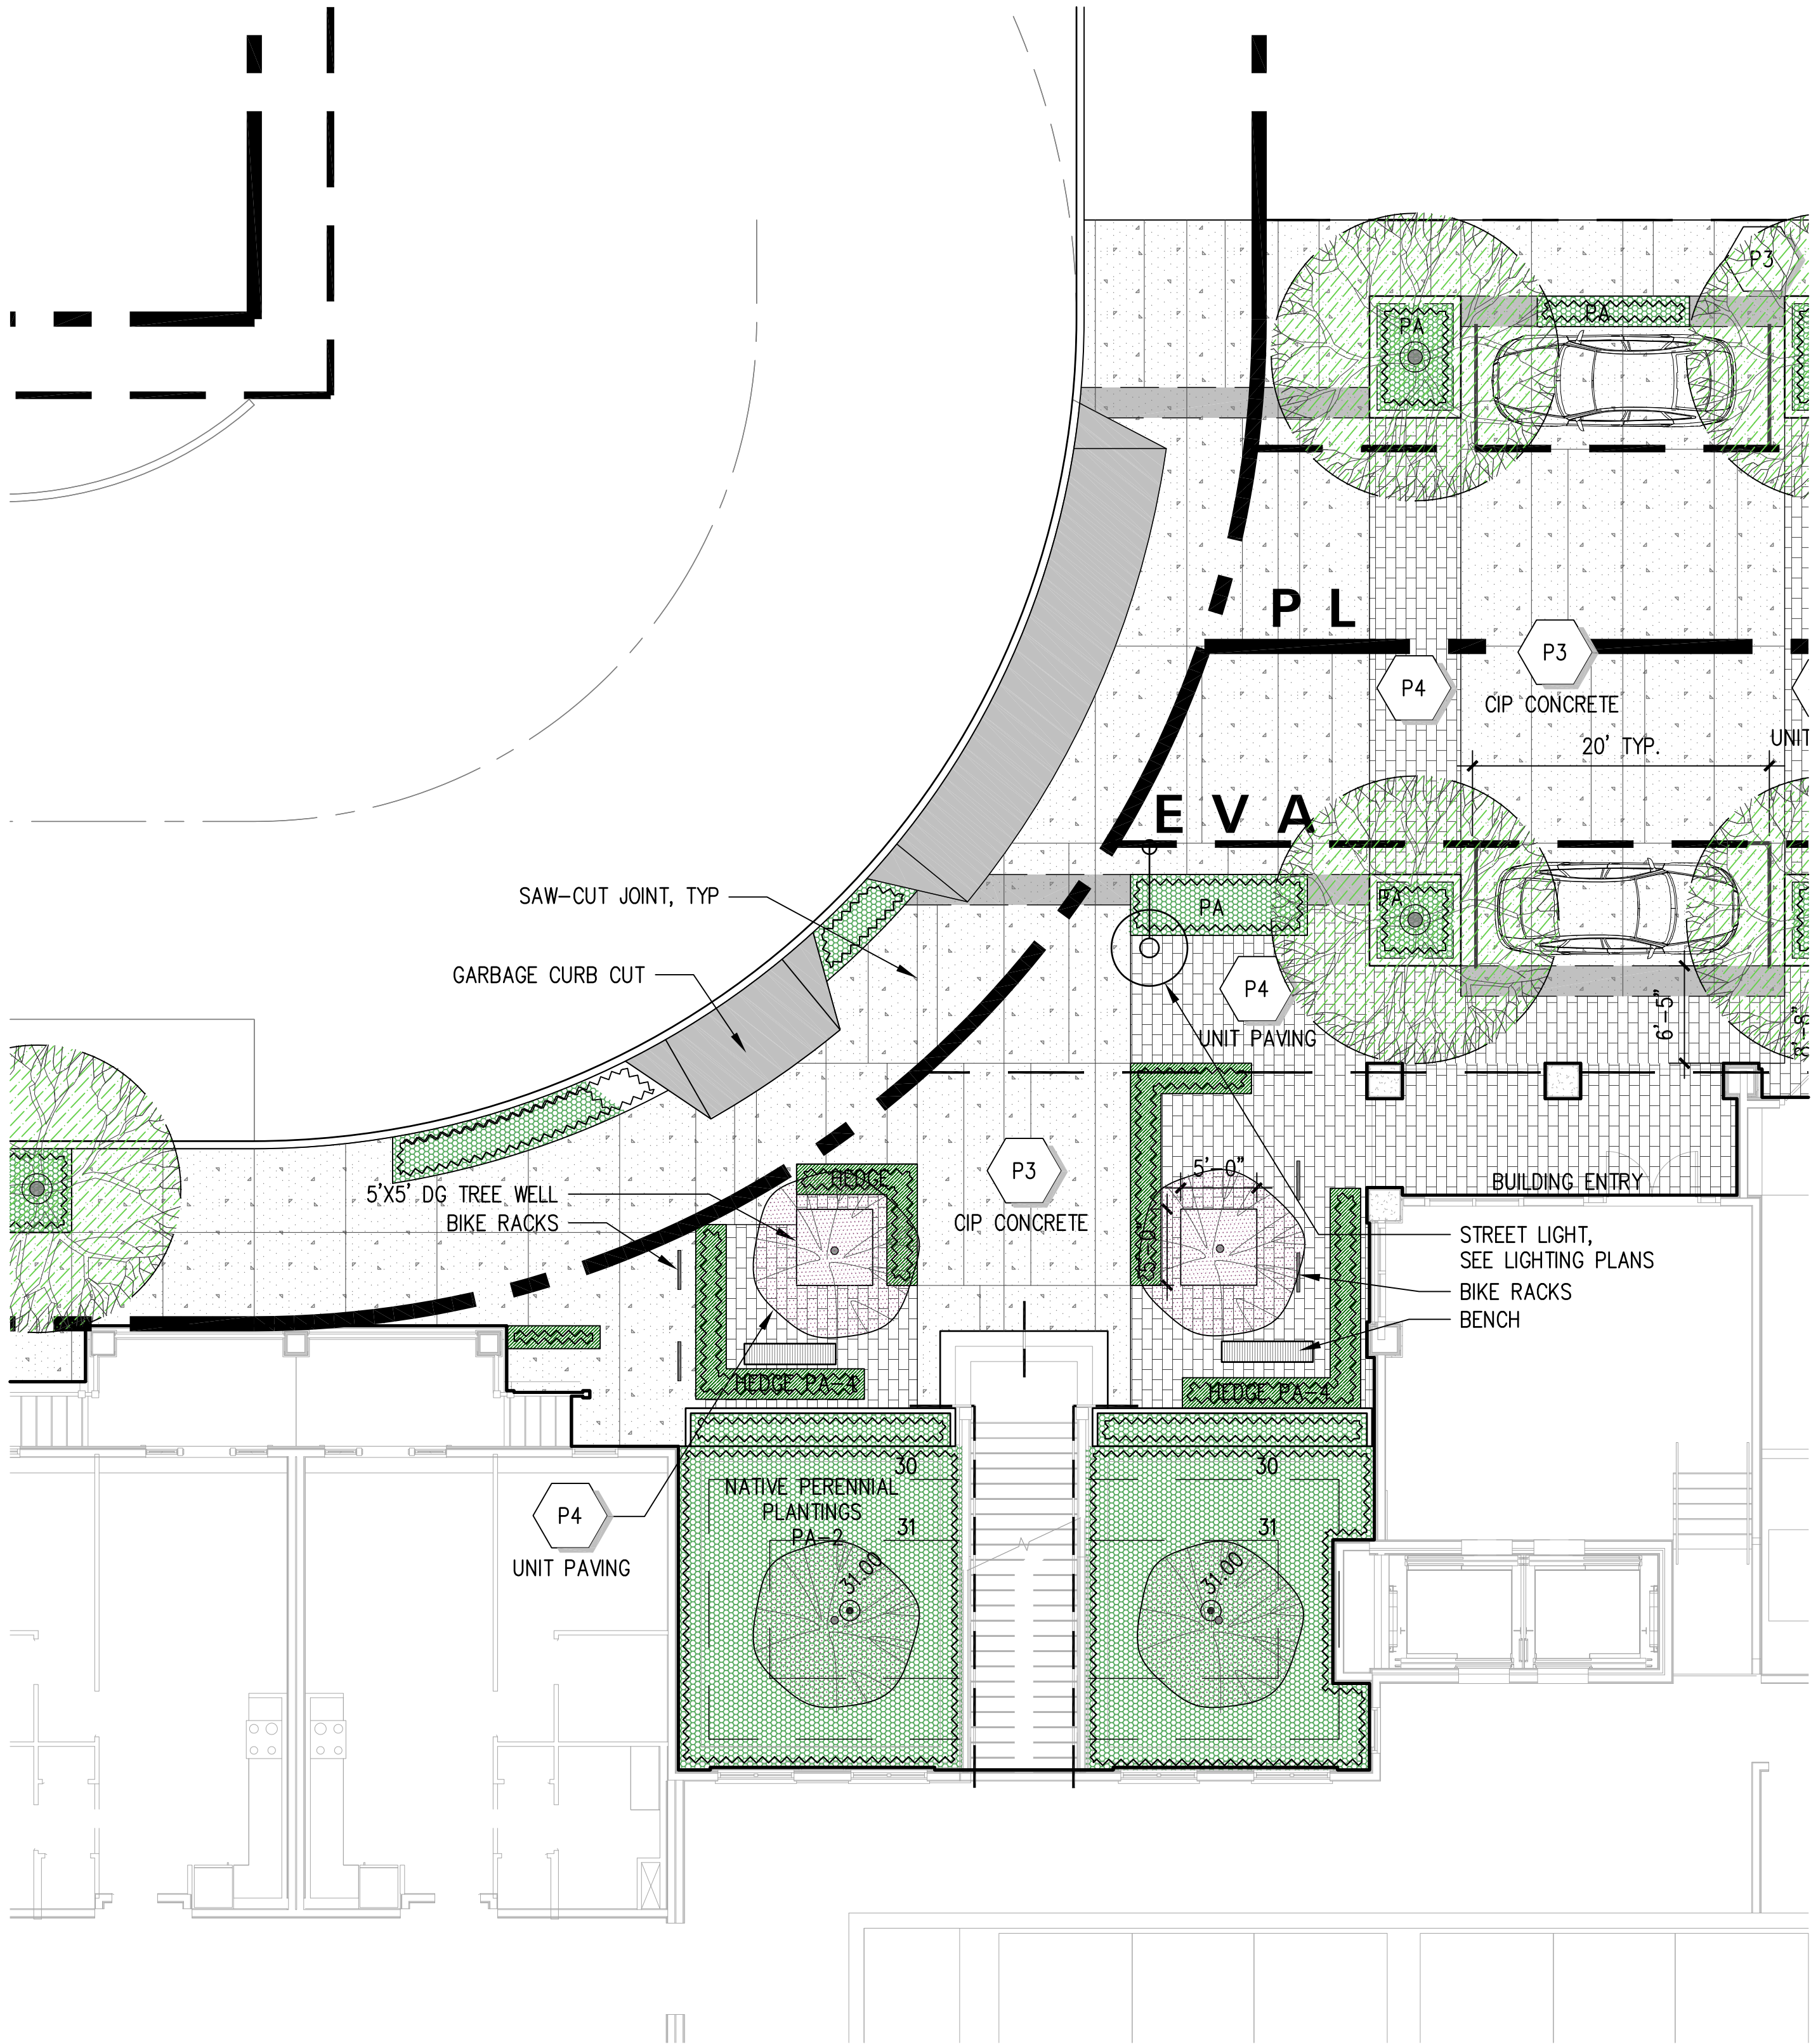


HERCULES PARCELS Q & R | HERCULES, CA

LOOP ROAD PLAZA ENLARGEMENT


swa
301 Battery Street
2 Mezzanine
San Francisco, California
94111-3212
United States
www.swagroup.com
+1.415.836.8770 o

BARS705

03.06.2018

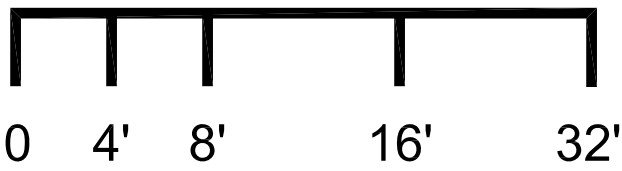

LANDSCAPE
L6.04

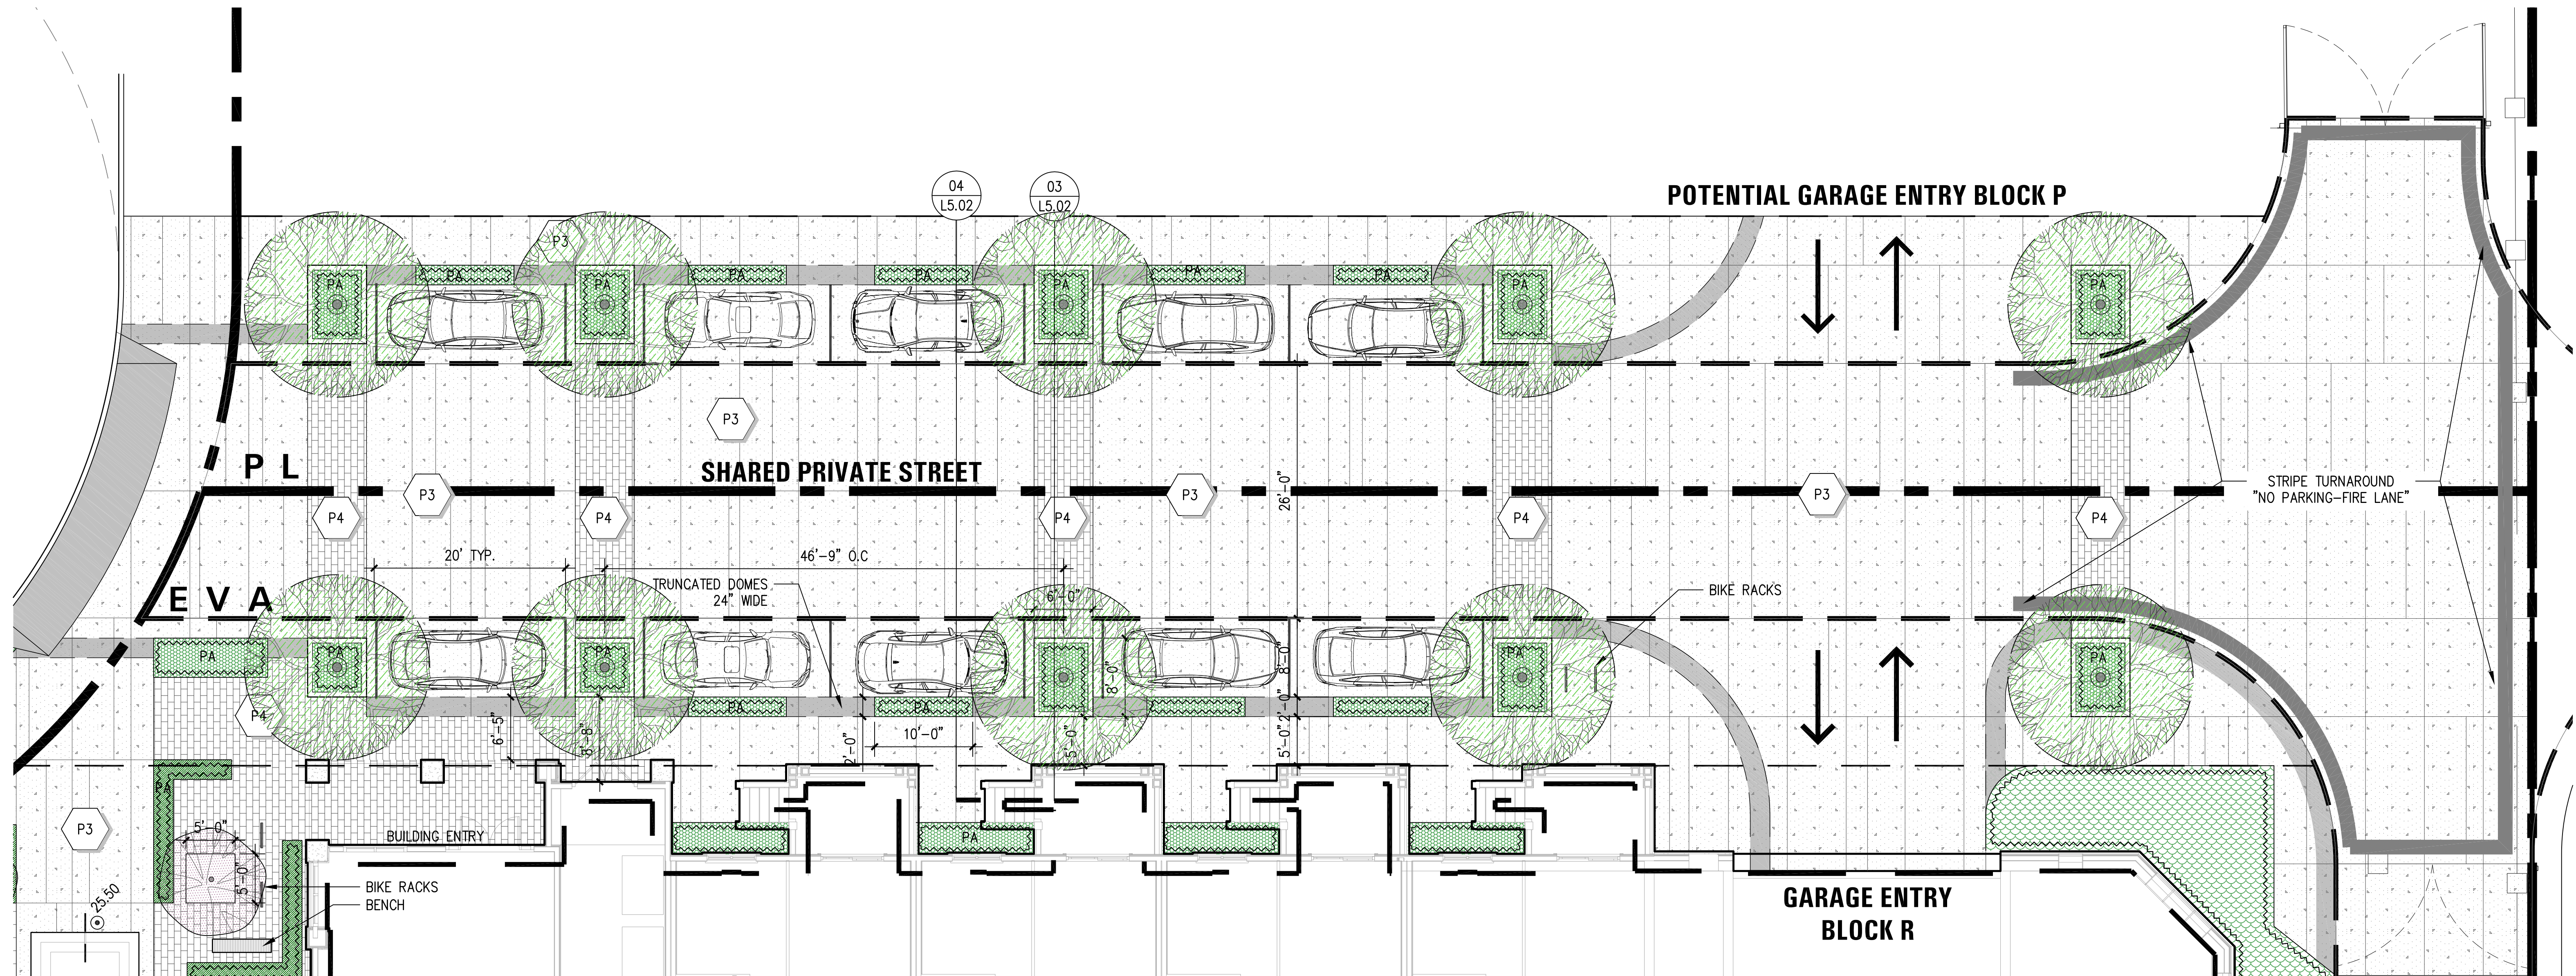

[FILE NAME : Z:\17025 HERCULES PARCELS Q&R\6 DRAWINGS\6.40 CAD\1-SITE\170824_BLOCK Q-R_TNDWG] [TAB : 34X22 BLDG SECTIONS - TITLE BLOCK] [October 18 - Wednesday 2017 - 6:14pm] [Plotted by : TNGUYEN] [Pen Setting : [Unknown]]
[XREF FILE NAME : - HBEX_TWBODY : HBEXSITE : HBEXTOP : HBEXUTL : HERCULES_MUIRPOINTELAYOUT : JMPPPLAN : JMPPRUTL : UNIT 1A : UNIT 1B : UNIT 1E : UNIT 1R A : UNIT 1R B : UNIT 2A : UNIT 2B : UNIT 2C : UNIT 2C MOD1 : UNIT 2D : UNIT 2F : UNIT 2G : UNIT 3A : W3422PER : W3422PERLOG]



HERCULES PARCELS Q & R


HERCULES, CA

LOOP ROAD SHARED STREET VIEW







swa
301 Battery Street
2 Mezzanine
San Francisco, California
94111-3212
United States
www.swagroup.com
+1.415.836.8770 o

BARS705

02.22.2017

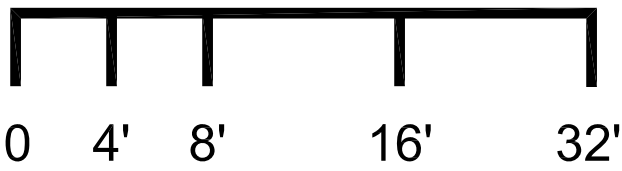

LANDSCAPE
L6.06

       LANDSCAPE AMENITIES

01 HARDCAPE MATERIALS

HERCULES PARCELS Q & R

HERCULES, CA

SITE FURNISHINGS